


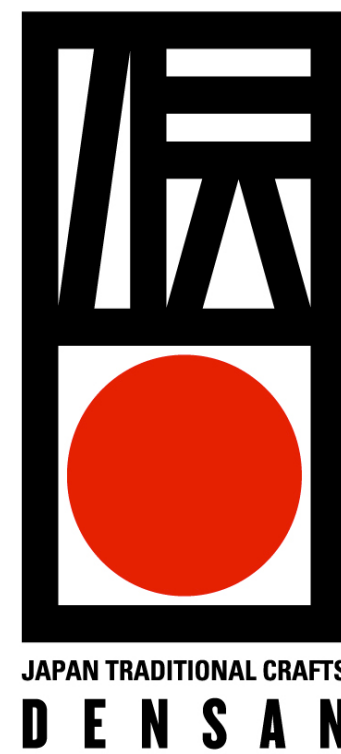

EVENT No. 190020000

STAND No. 8.0 M55

COSTOMER No. 15022046

DESIGN BY: TRUNK LTD.

2018.9th.Nov

【仕上げ/finish schedule】



- ・床/Floor
 - *Carpet(roll) PE-53/Sangetsu
 - *FL+30 床下配線
for Under-floor wiring
- ・壁/Wall
 - *Wall paper(White)
 - *Point wall/ graphic sheet



突っ張り棒
/TENSION HANGING POLE
※ハンガーは備品にて用意



突っ張り棒+カーテン
/TENSION HANGING POLE with Curtain/white

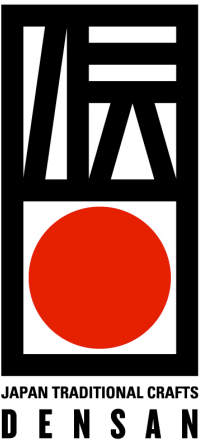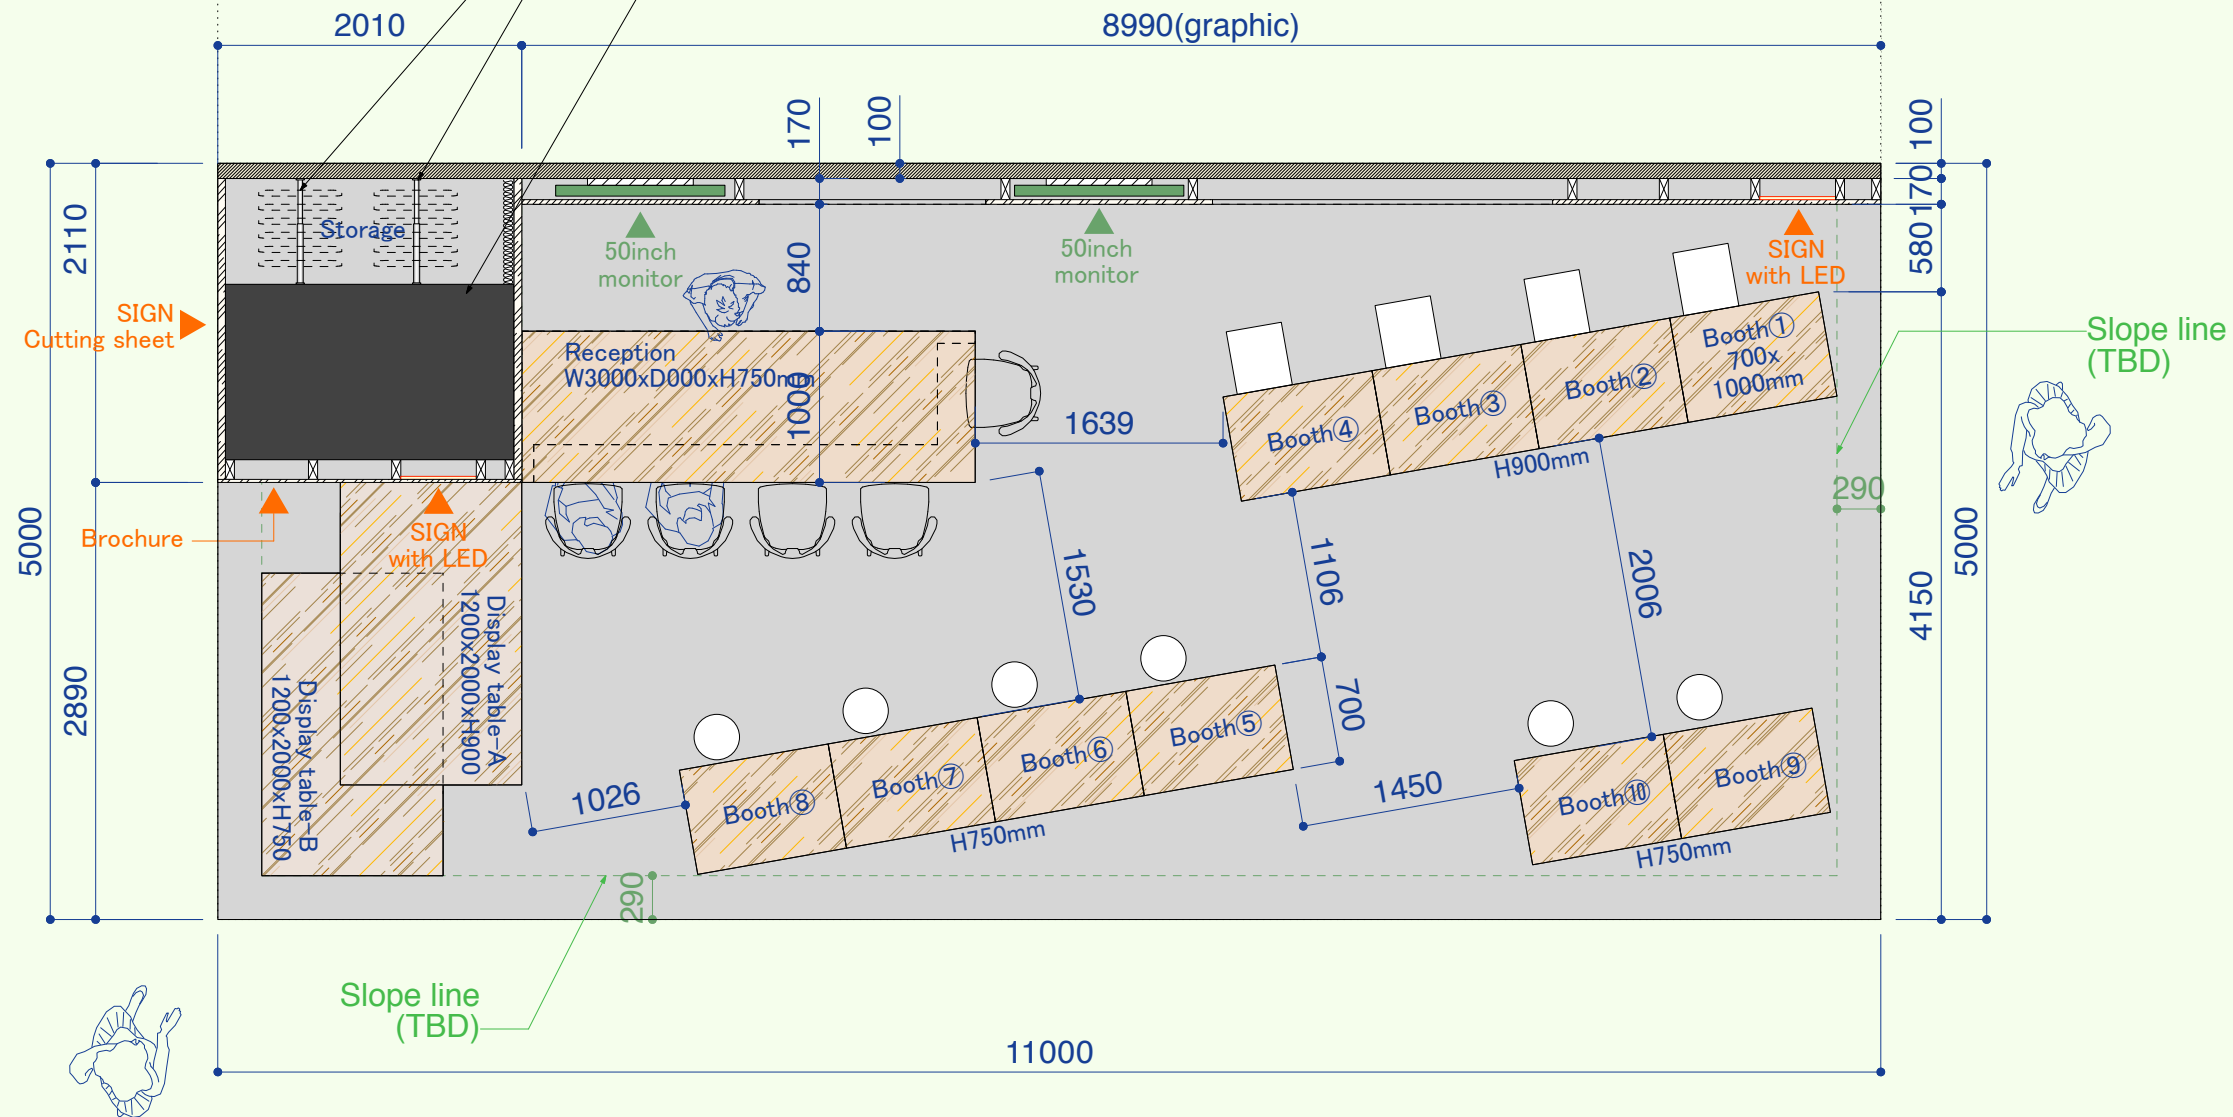

TITLE

LAYOUT

STAND No. 8.0 M55

55sqm/CH3500mm

REVISIONS

2018/11/01

2018/11/02

2018/11/09

EVENT No.

190020000

COSTOMER No.

15022046

DESIGN BY:

TRUNK LTD.

DRAWN BY:

I.Ishikawa

SCALE:

1:50

SHEET No.

01

TRUNK LTD.
design consulting & produce

Seizan I #1002
2-26-32 Minamiaoyama Minato-ku
TOKYO JAPAN #107-0062

T: +81-3-6804-1261
F: +81-3-3403-2360

【リース備品/Rental equipment】

- ・50インチモニター、取り付け金物
/50inch monitor with hanging metal parts
※映像をUSBにて流す仕様
- ・ダイニングチェア@レセプションテーブル
/Dining chair
- ・ハイチェア@Booth①～④ /High chair
- ・スツール@Booth⑥～⑩ /Stool
- ・ハンガー@Strage /Hanger

- ・50インチモニター、取り付け金物
/50inch monitor with hanging metal parts
※映像をUSBにて流す仕様



x 2set

- Dining chair @Reception table
MAUI chair/Kartell
Product No. SFCH-K2870-2M



x 5set

- Stool
PRINCE AHA/KARTELL
Product No. SFCH-K8810-1N-WHT

 




x 6set

- High chair
LEM/Shin Azumi




x 4set



Symbol	Note/Spec	Location	QTY
	配線ダクト DH0211/Panasonic Track rail for spot light	Booth上部 Above of booth	4M x 2 2M x 1
	テーブルランプ(選定中) Desk lamp	-Reception table -Display table	2台 ※TBD
	スポットライト NTS02131W LE1/Panasonic Spot light	Booth上部 Above of booth	20台
	間接照明 Strip LED with cover	-On the wall -Sign with LED	4M x 2 2M x 1
	コンセントBOX Outlet box	-Reception table -Booth	
	壁コンセント Wall outlet	-Reception table	
	モニター用電源/ケーブル Cable antenna outlet for monitor	-On the wall	

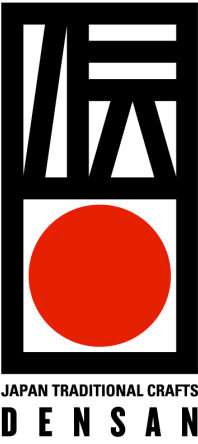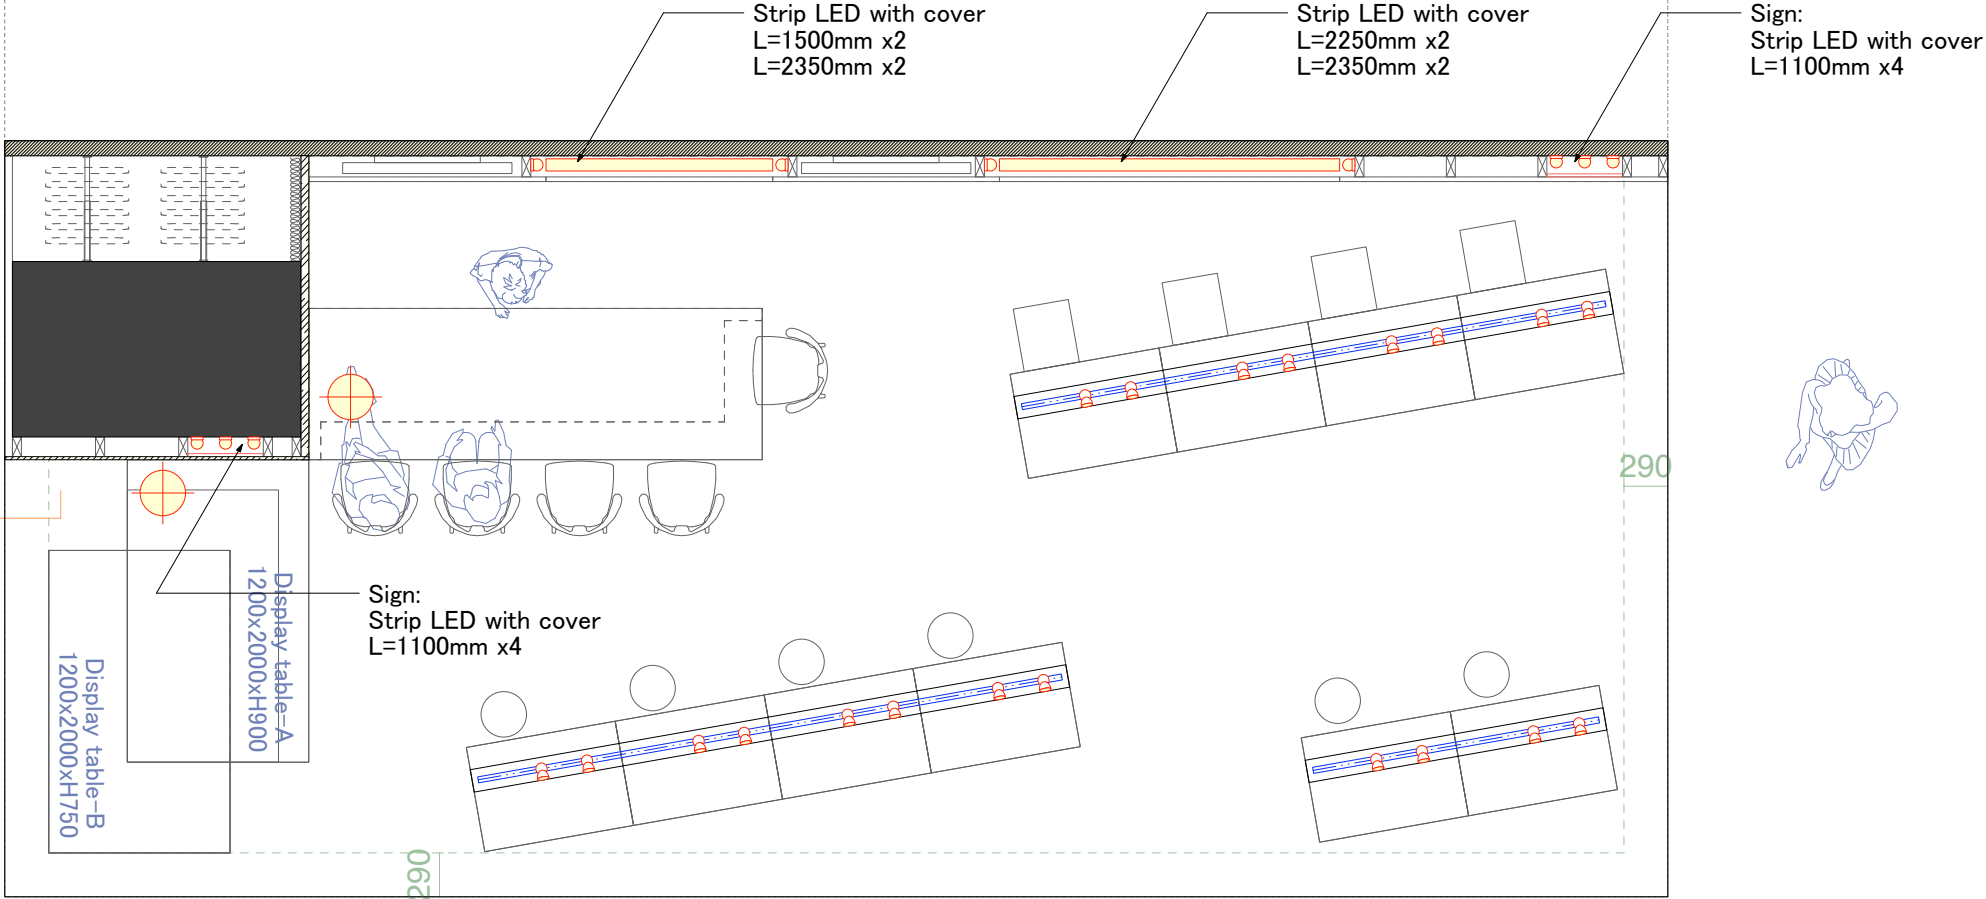

TITLE
LIGHTING PLAN
STAND No. 8.0 M55
55sqm/CH3500mm
REVISIONS
2018/11/09
EVENT No.
190020000
COSTOMER No.
15022046
DESIGN BY:
TRUNK LTD.
DRAWN BY:
I.Ishikawa
SCALE:
1:50
SHEET No.
02

 TRUNK LTD.
design consulting & produce
Seizan I #1002
2-26-32 Minamiaoyama Minato-ku
TOKYO JAPAN #107-0062
T: +81-3-6804-1261
F: +81-3-3403-2360

Symbol	Note/Spec	Location	QTY
	配線ダクト DH0211/Panasonic Track rail for spot light	Booth上部 Above of booth	4M x 2 2M x 1
	テーブルランプ(選定中) Desk lamp	-Reception table -Display table	2台 ※TBD
	スポットライト NTS02131W LE1/Panasonic Spot light	Booth上部 Above of booth	20台
	間接照明 Strip LED with cover	-On the wall -Sign with LED	4M x 2 2M x 1
	コンセントBOX Outlet box	-Reception table -Booth	
	壁コンセント H=800mm Wall outlet	-Reception table	
	モニター用電源/ケーブル Cable antenna outlet for monitor	-On the wall	

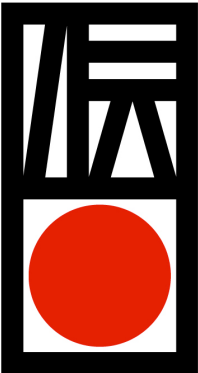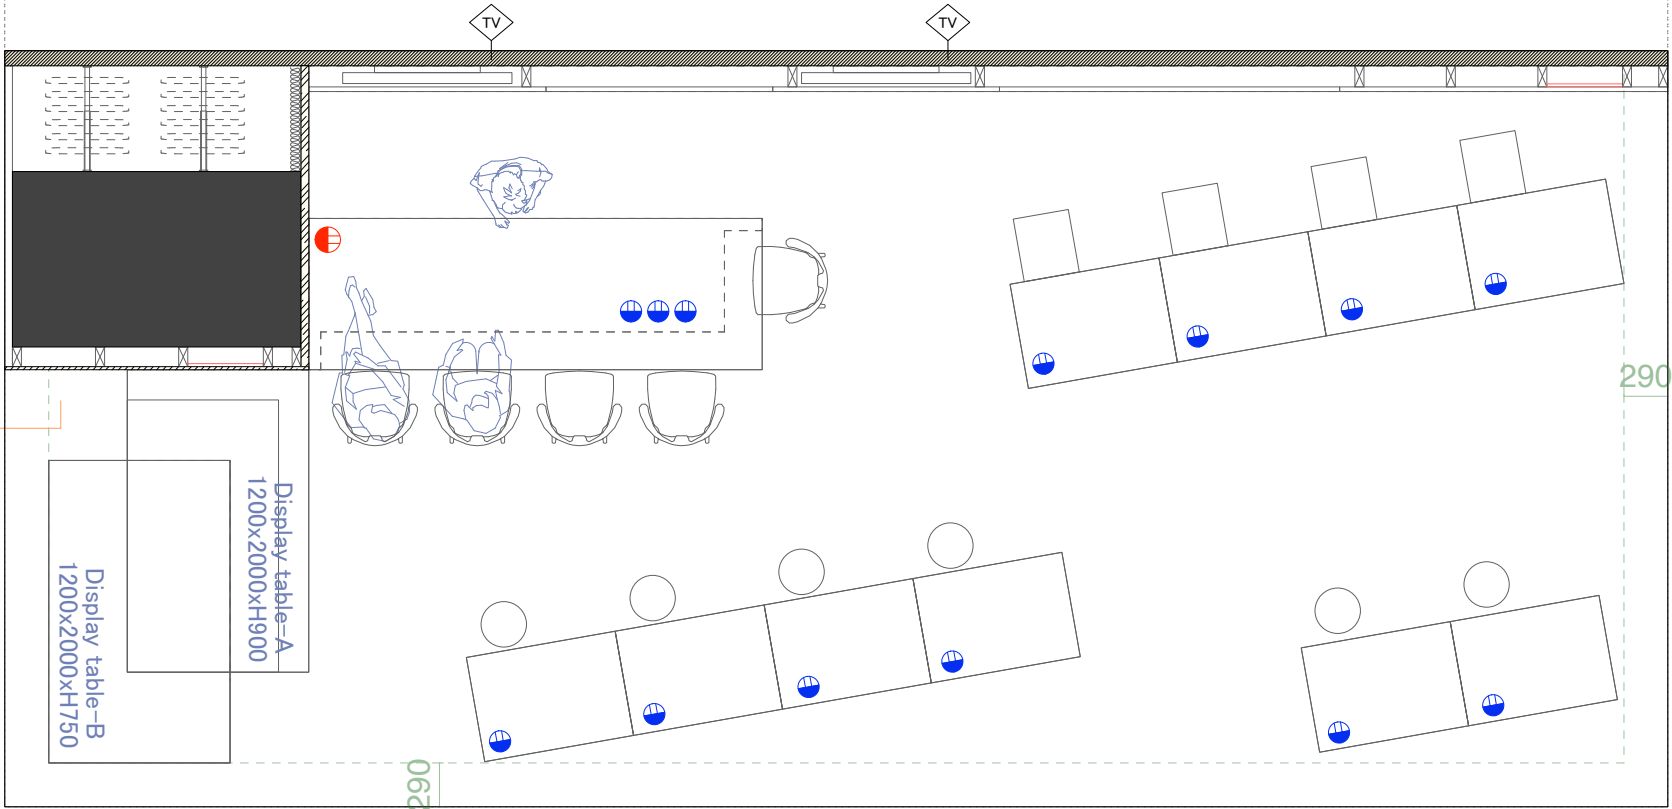

JAPAN TRADITIONAL CRAFTS
DEN SAN

TITLE

POWER AND OUTLET

STAND No. 8.0 M55

55sqm/CH3500mm

REVISIONS

2018/11/09

EVENT No.

190020000

COSTOMER No.

15022046

DESIGN BY:

TRUNK LTD.

DRAWN BY:

I.Ishikawa

SCALE:

1:50


SHEET No.

03






TRUNK LTD.
design consulting & produce

Seizan I #1002
2-26-32 Minamiaoyama Minato-ku
TOKYO JAPAN #107-0062


T: +81-3-6804-1261
F: +81-3-3403-2360

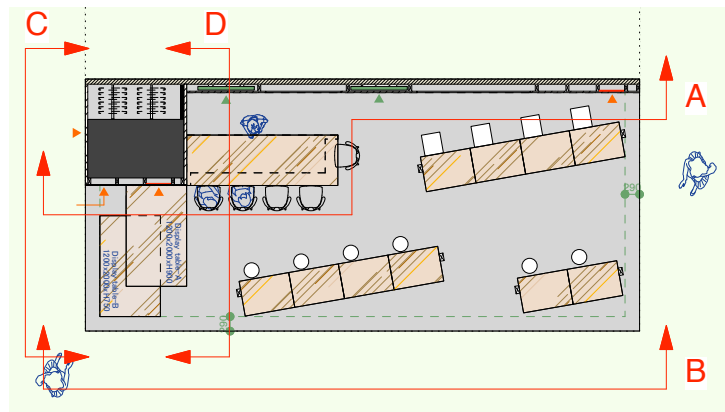


KEY PLAN

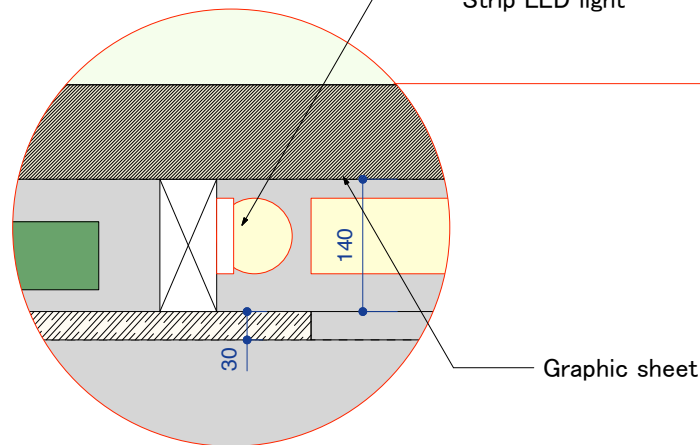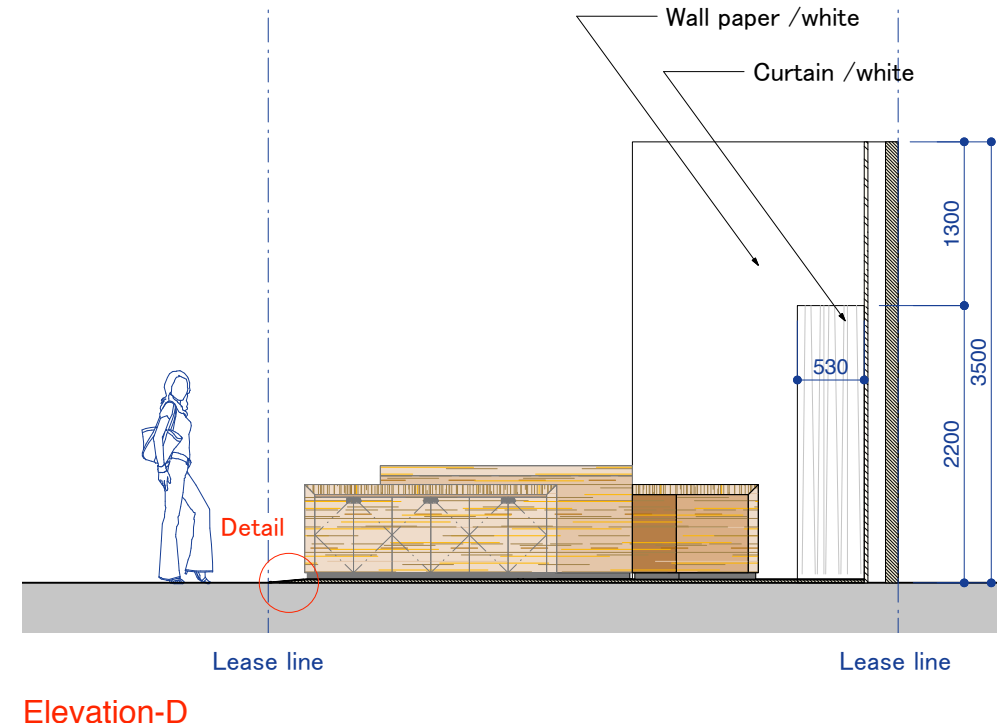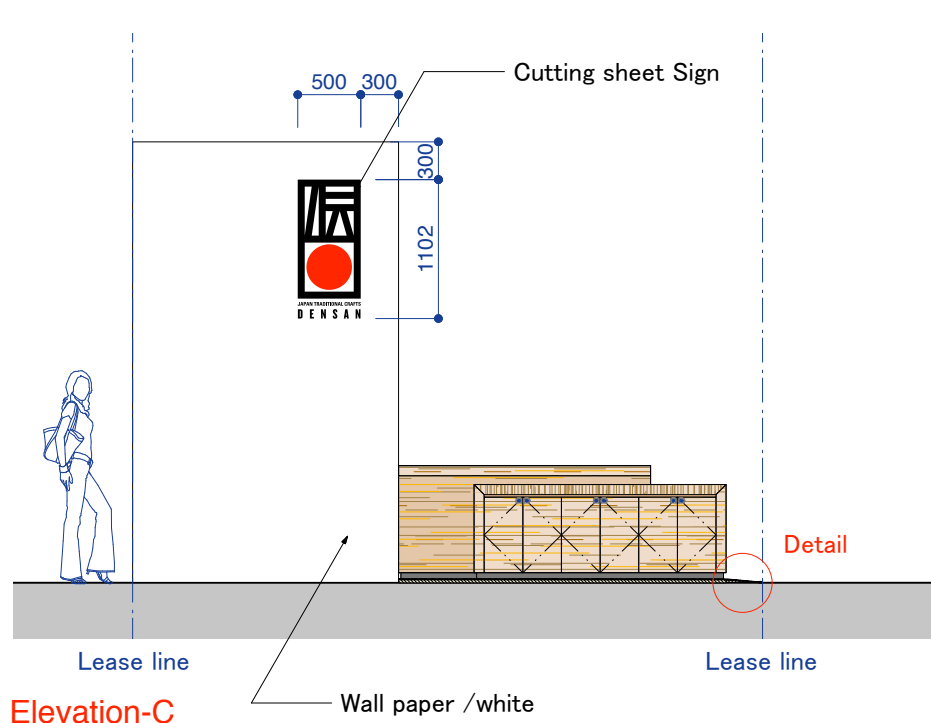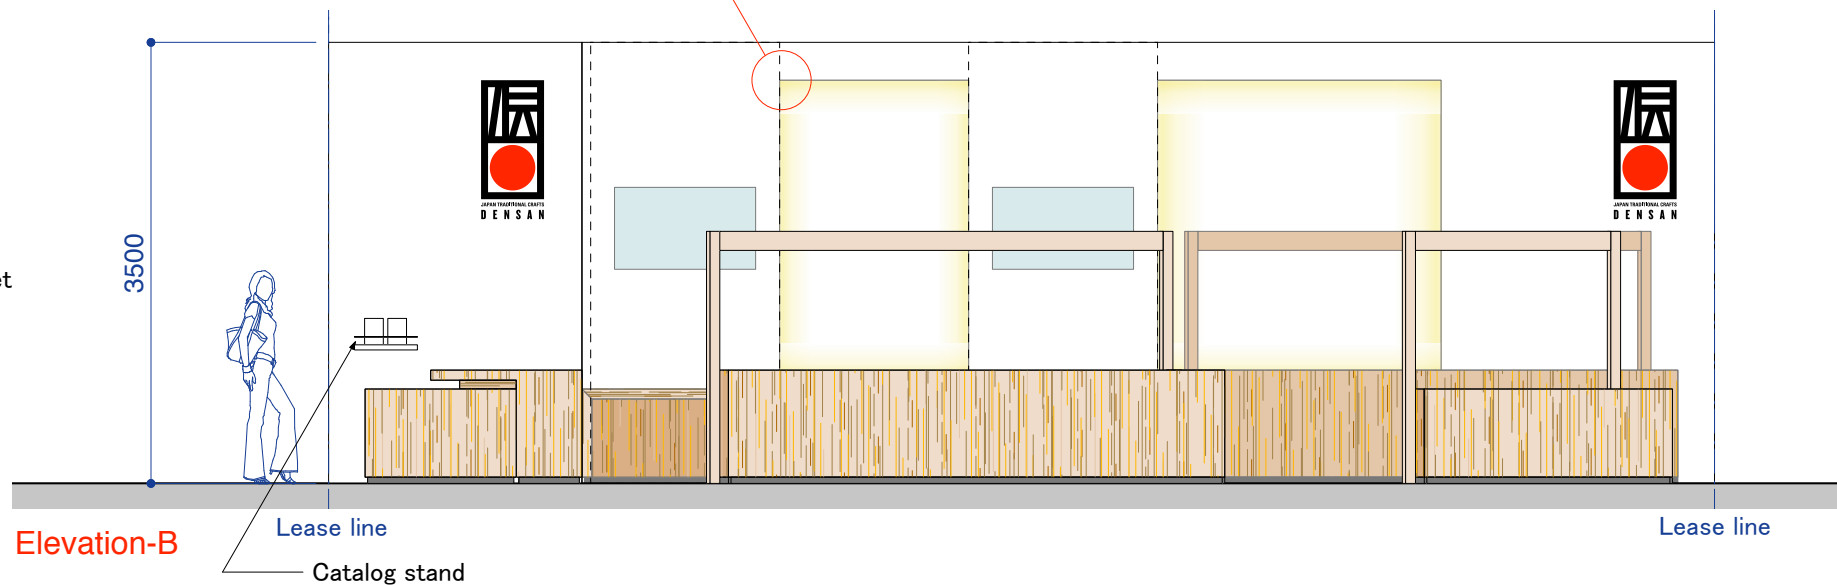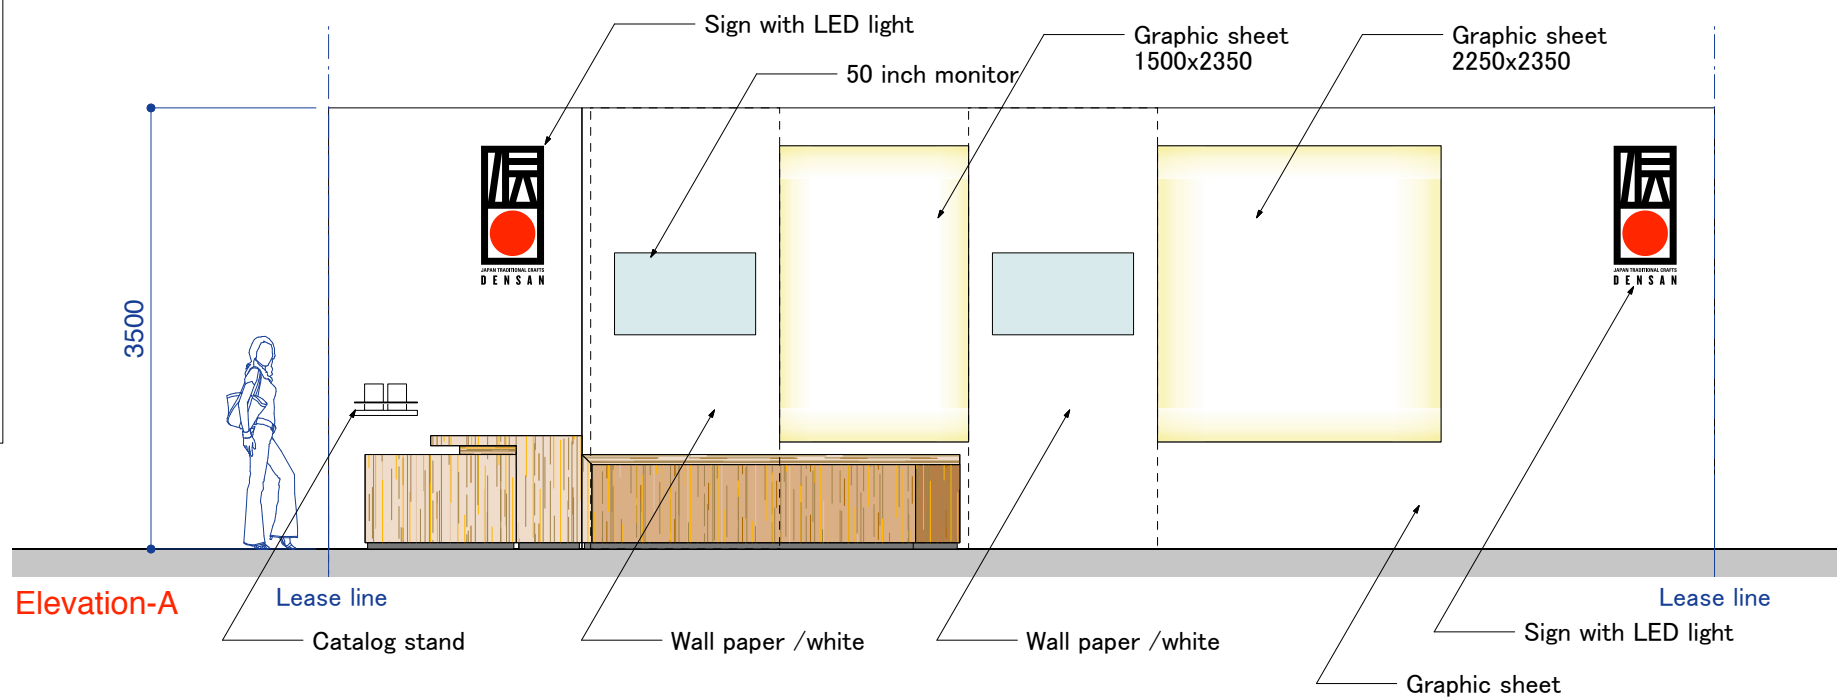

Wall Detail
scale:1/8

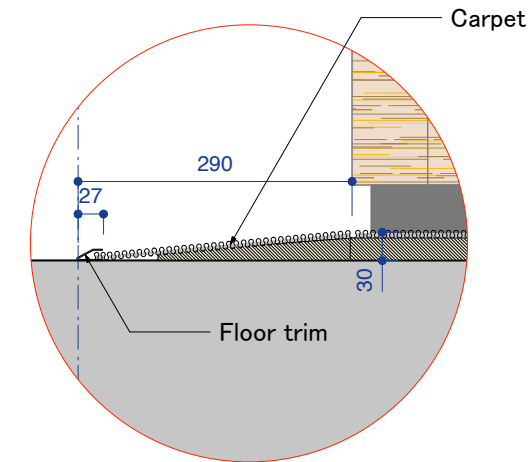

Floor Detail
scale:1/8

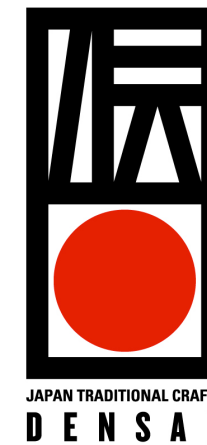

TITLE

ELEVATION

STAND No. 8.0 M55

55sqm/CH3500mm

REVISIONS

2018/11/09

EVENT No.

190020000

COSTOMER No.

15022046

DESIGN BY:

TRUNK LTD.

DRAWN BY:

I.Ishikawa

SCALE:

1:60


SHEET No.

04

TRUNK LTD.
design consulting & produce


Seizan I #1002
2-26-32 Minamiaoyama Minato-ku
TOKYO JAPAN #107-0062

T: +81-3-6804-1261
F: +81-3-3403-2360


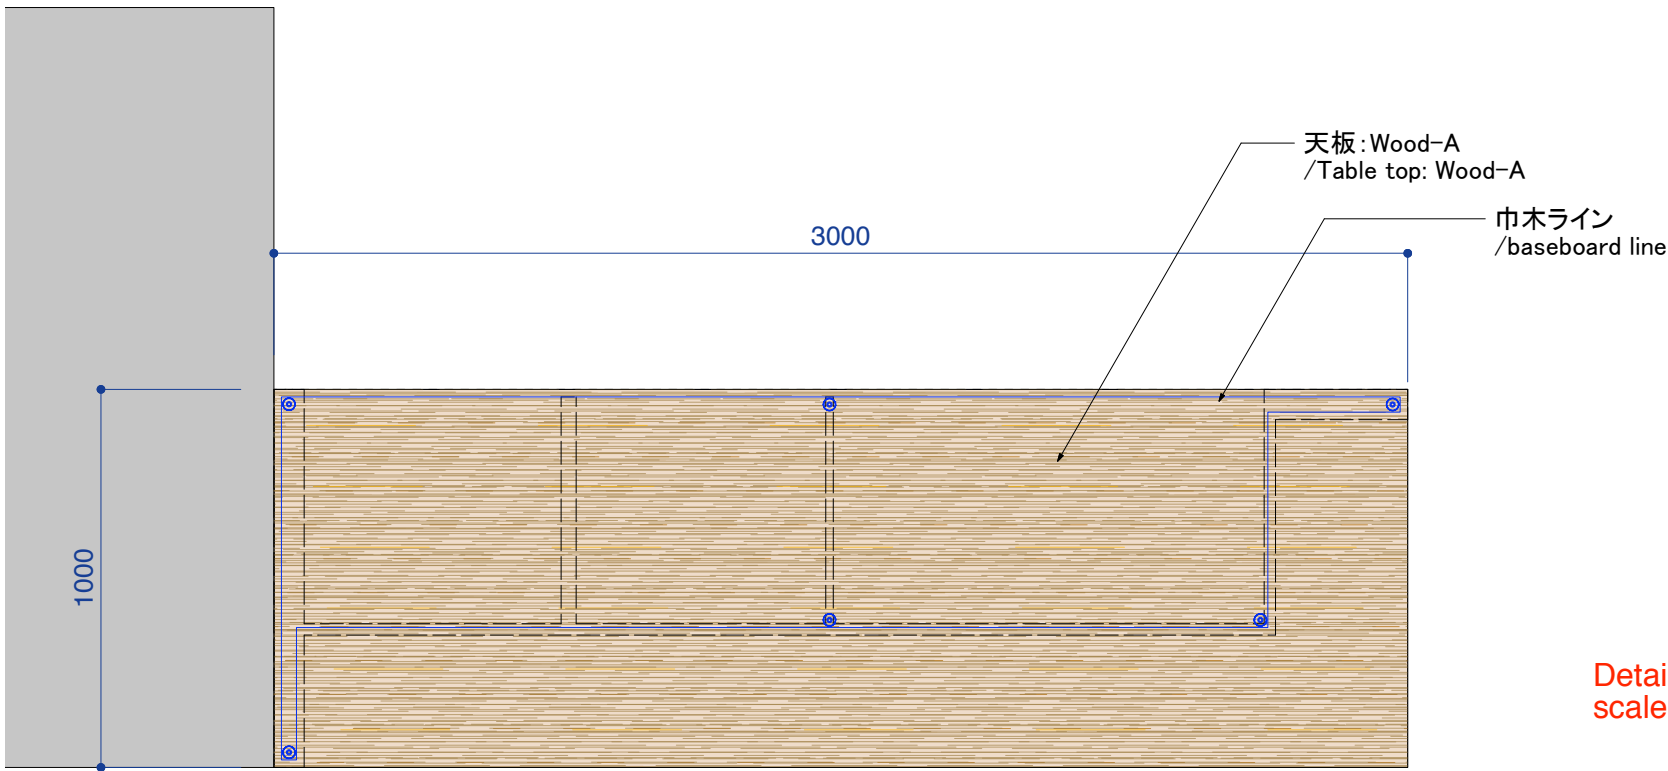


【仕上げ/finish schedule】


Wood-A/facia : メラミン化粧板/Melamine decorative plate TJY 2070K/AICA	
Wood-B/inside finish : ポリエステル化粧板/Polyester-resin treaed plywood LP-2070/AICA	
Metal-A/baceboard メラミン化粧板/Melamine decorative plate ME-2932/AICA	

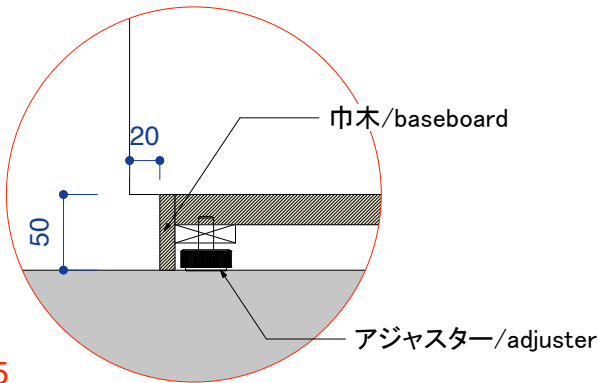

Detail
scale:1/5

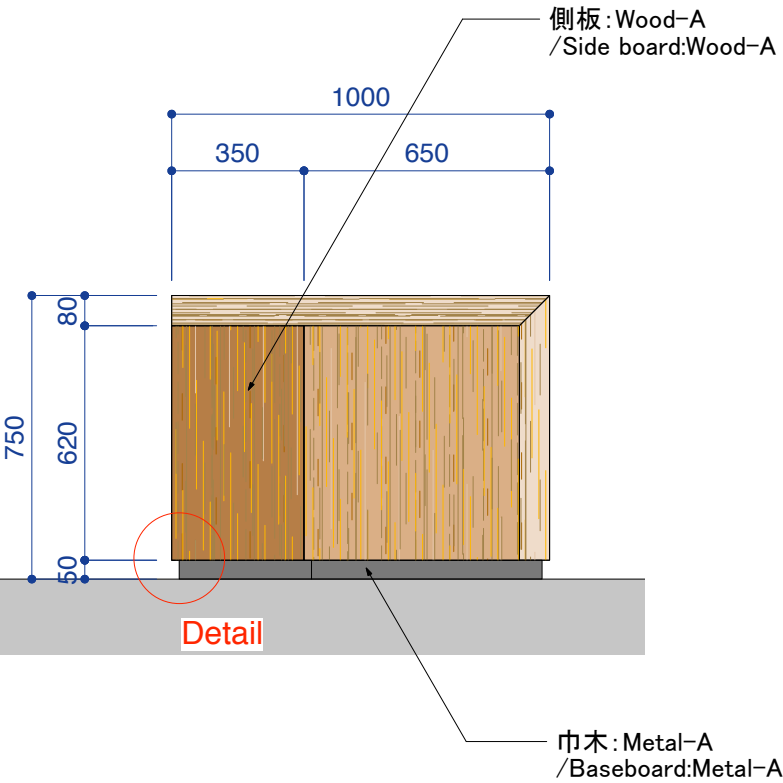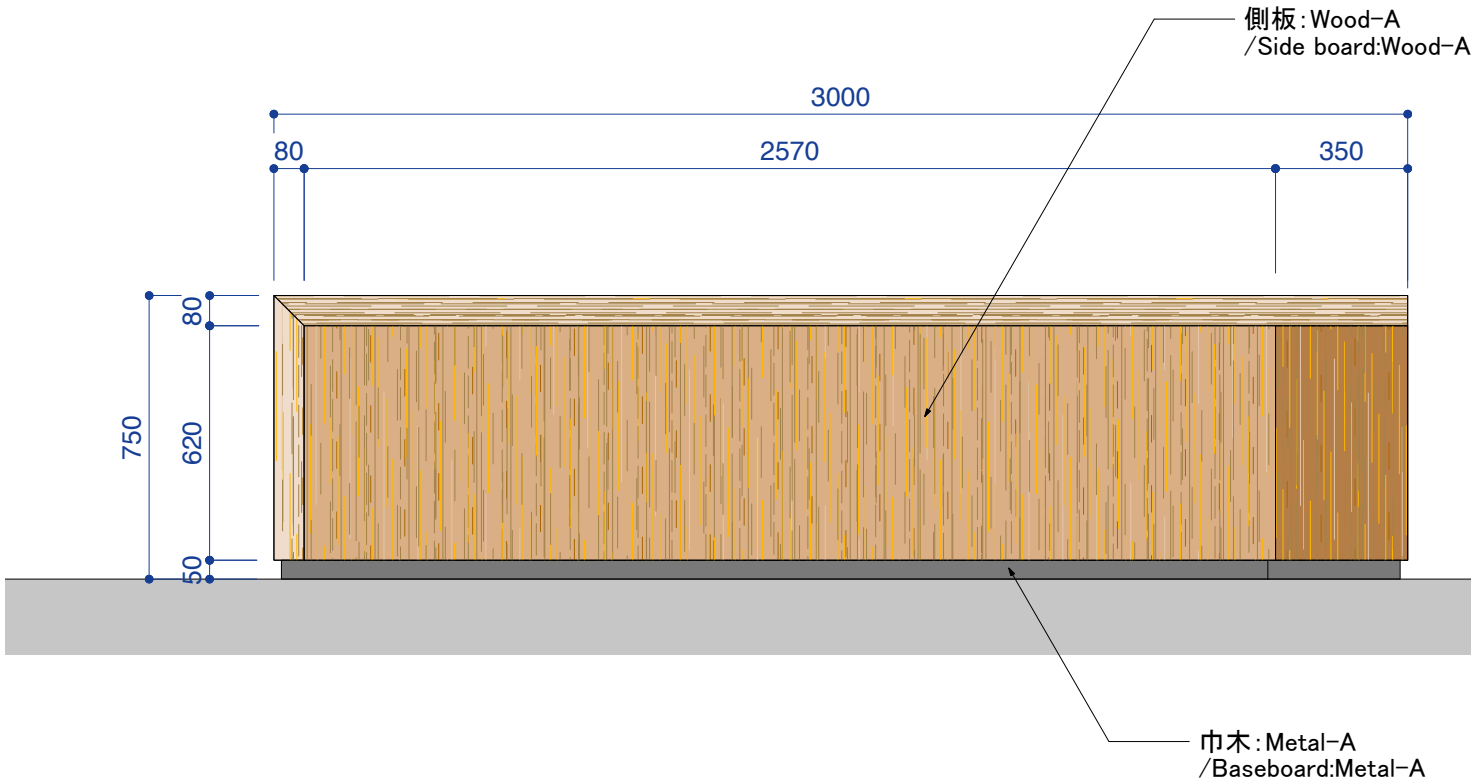

Detail

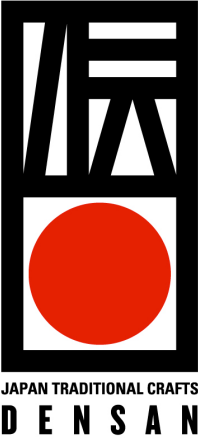

TITLE

RECEPTION TABLE-1

STAND No. 8.0 M55

55sqm/CH3500mm

REVISIONS

2018/11/09

EVENT No.

190020000

COSTOMER No.

15022046

DESIGN BY:

TRUNK LTD.

DRAWN BY:

I.Ishikawa

SCALE:

1:20

SHEET No.

05

TRUNK LTD.
design consulting & produce

Seizan I #1002
2-26-32 Minamiaoyama Minato-ku
TOKYO JAPAN #107-0062







T: +81-3-6804-1261
F: +81-3-3403-2360

【仕上げ/finish schedule】

Wood-A/facia :
メラミン化粧板 / Melamine decorative plate
TJY 2070K/AICA

Wood-B/inside finish :
ポリ版化粧ボード / Polyester-resin treaed plywood
LP-2070/AICA

Metal-A/baceboard
メラミン化粧板 / Melamine decorative plate
ME-2932/AICA

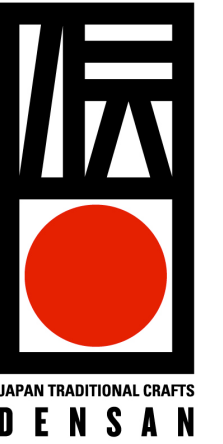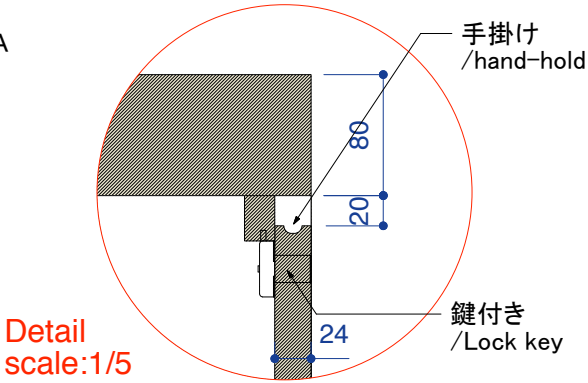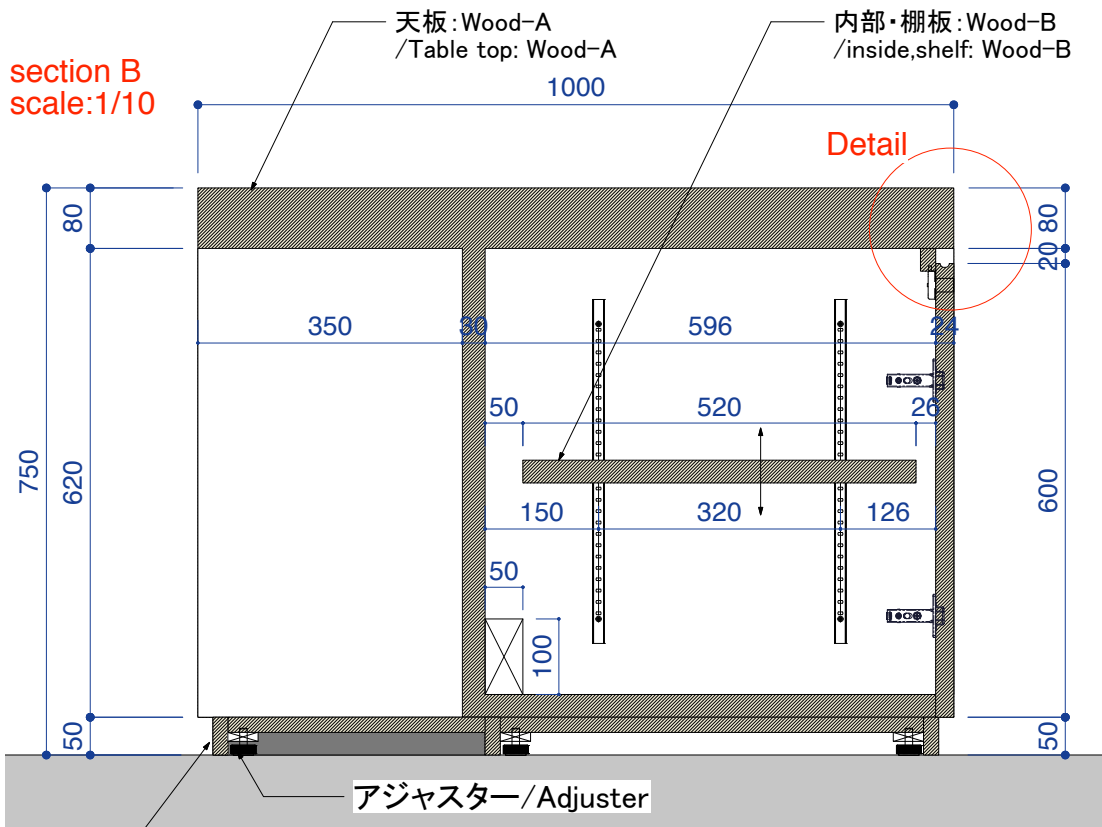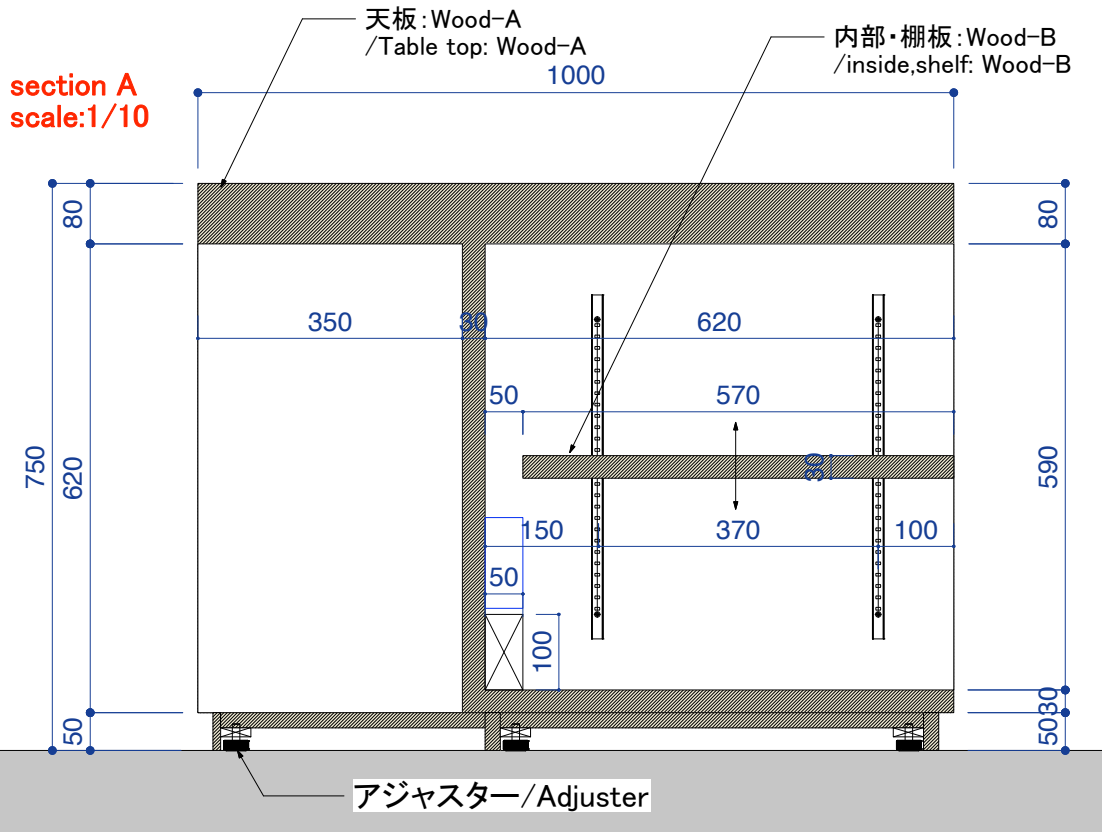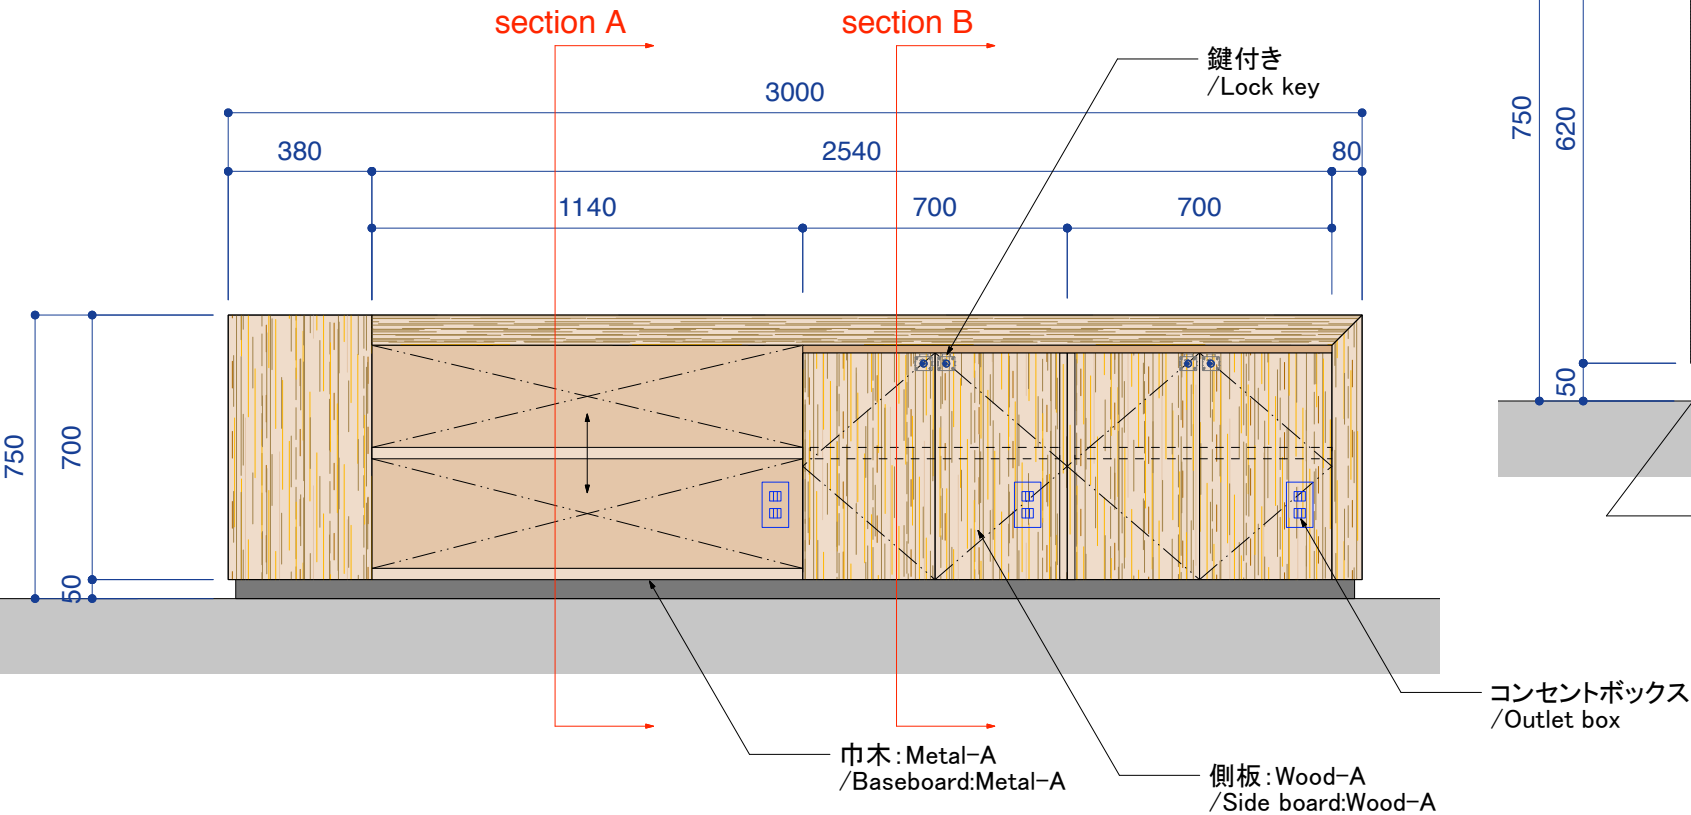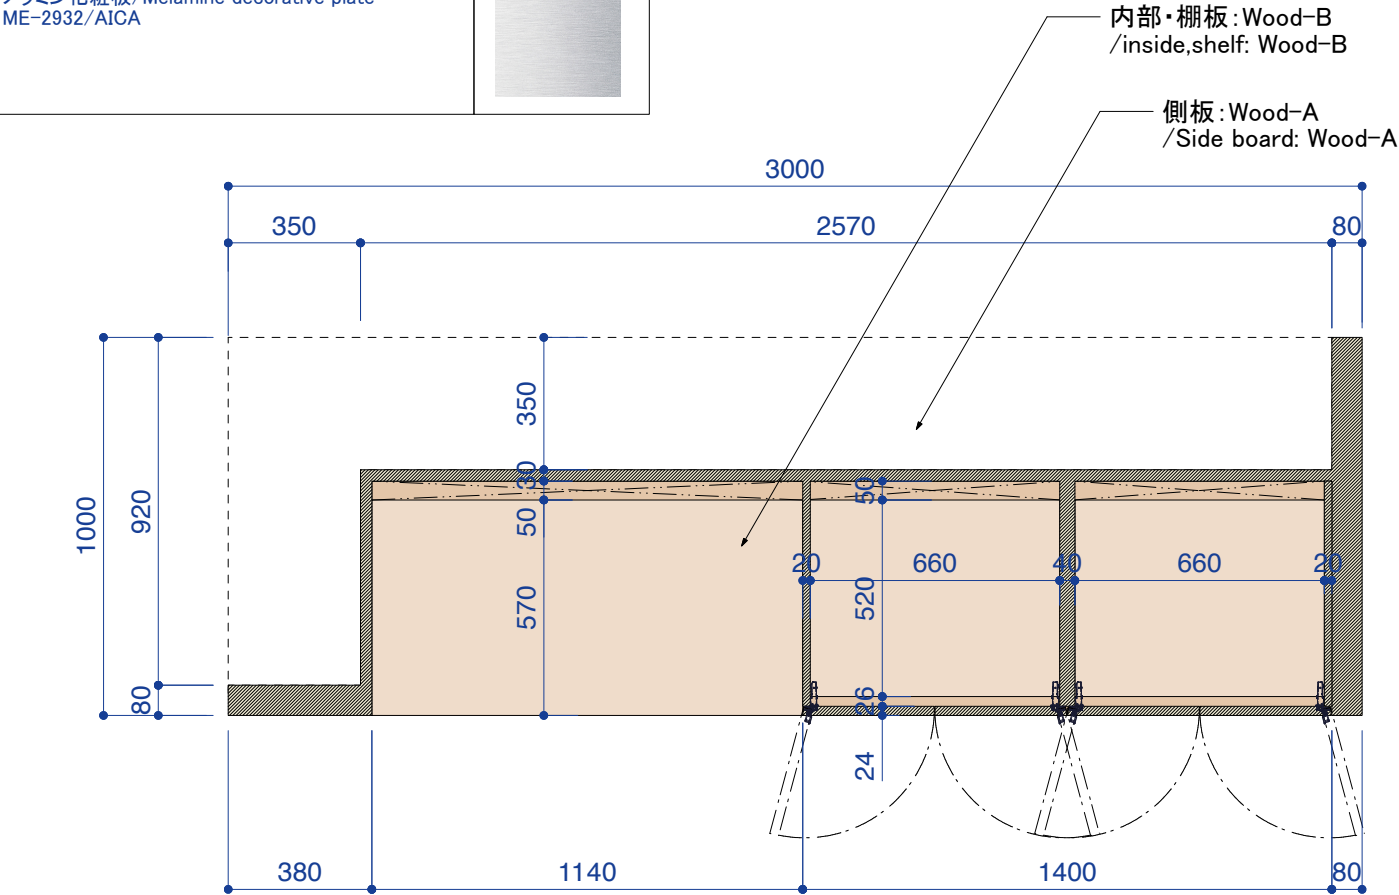

TITLE

RECEPTION TABLE-2

STAND No. 8.0 M55

55sqm/CH3500mm

REVISIONS

2018/11/09

EVENT No.

190020000

COSTOMER No.

15022046

DESIGN BY:

TRUNK LTD.

DRAWN BY:

I.Ishikawa

SCALE:

1:20,1:10

SHEET No.

06

TRUNK LTD.
design consulting & produce

Seizan I #1002
2-26-32 Minamiaoyama Minato-ku
TOKYO JAPAN #107-0062




T: +81-3-6804-1261
F: +81-3-3403-2360

【仕上げ/finish schedule】


Wood-A/facia :
メラミン化粧板/Melamine decorative plate
TJY 2070K/AICA

Wood-B/inside finish :
ポリエステル化粧板/Polyester-resin treaed plywood
LP-2070/AICA




Metal-A/baseboard
メラミン化粧板/Melamine decorative plate
ME-2932/AICA

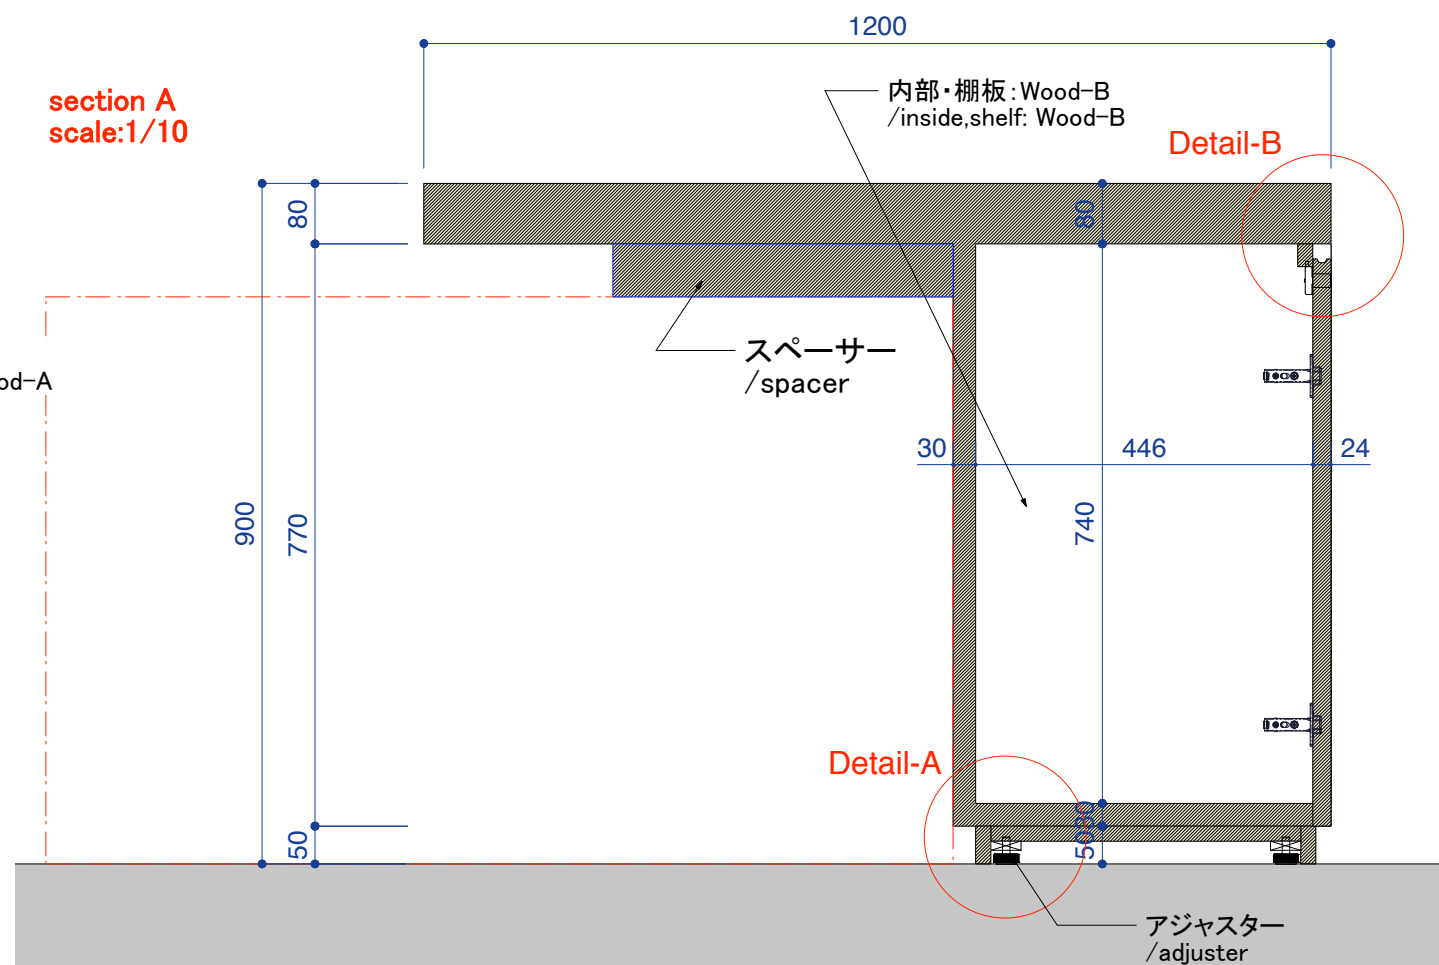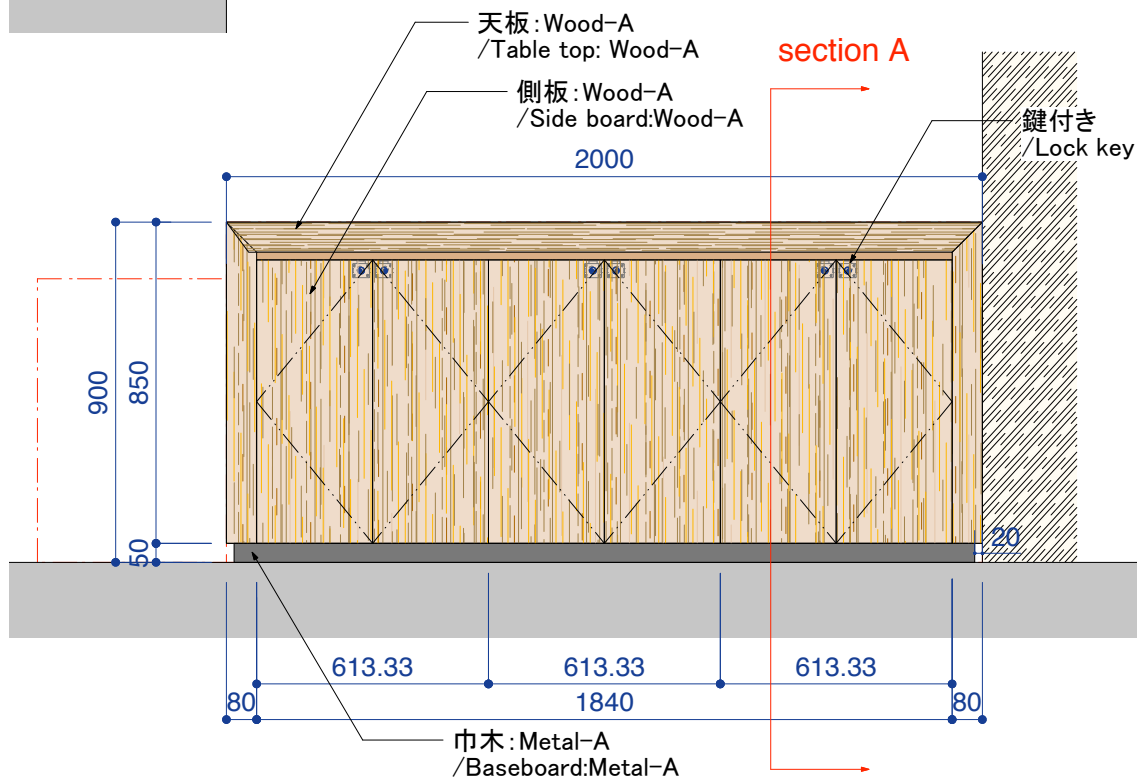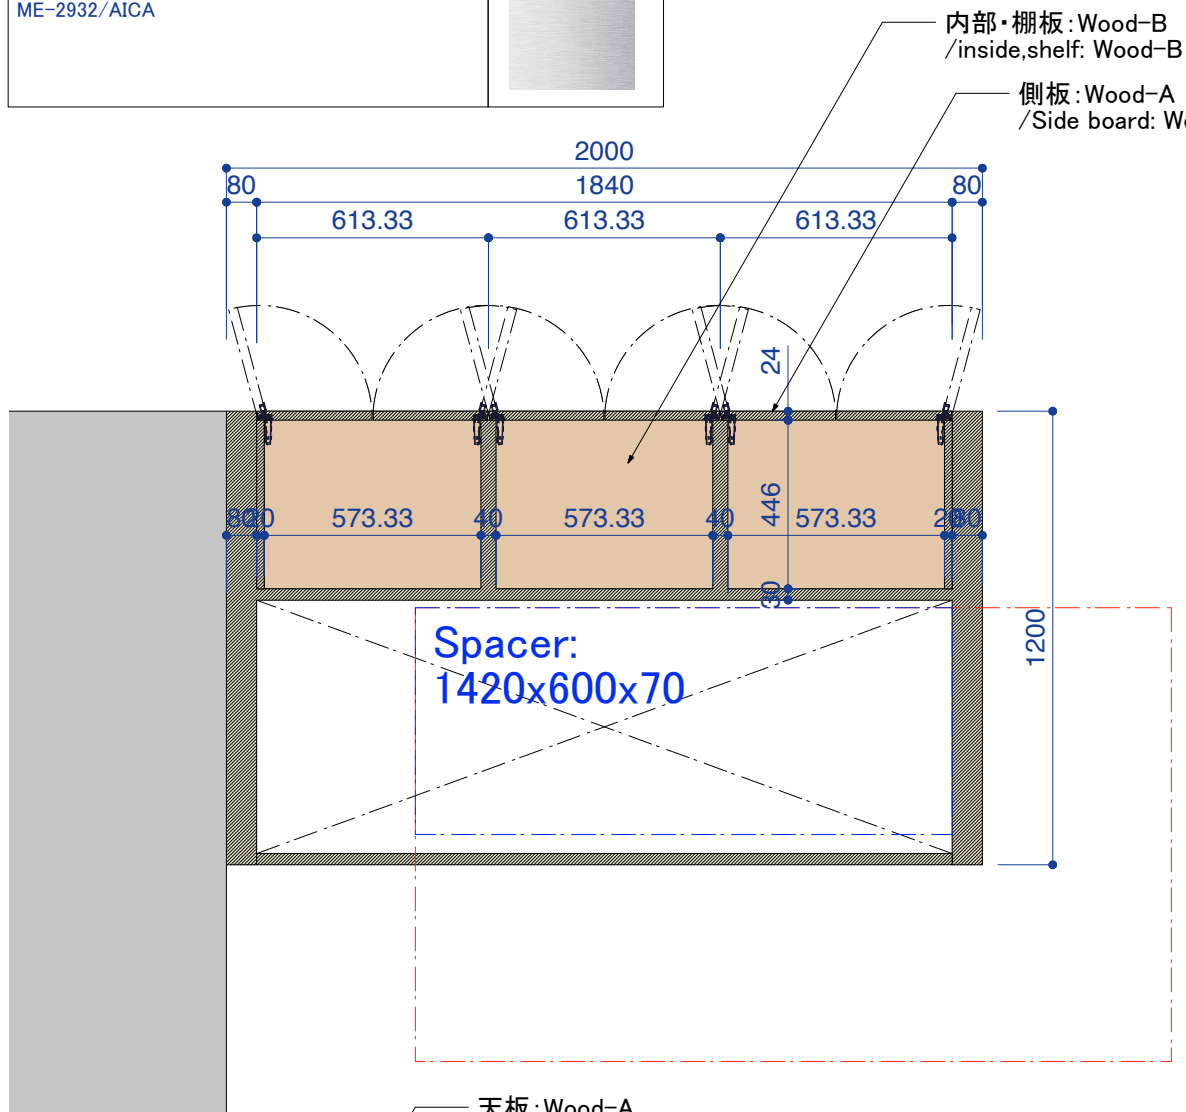

Detail-A
scale:1/5

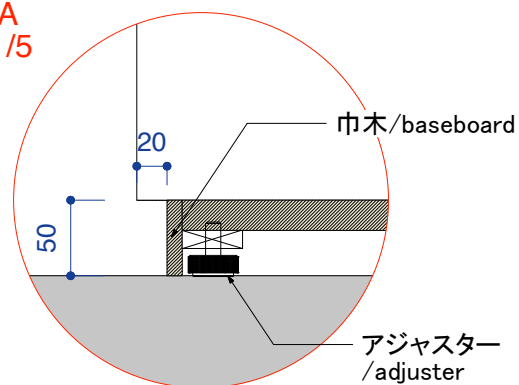

Detail-B
scale:1/5

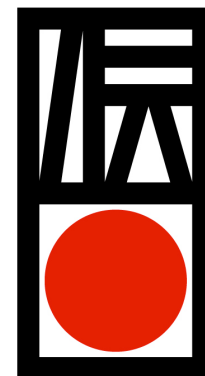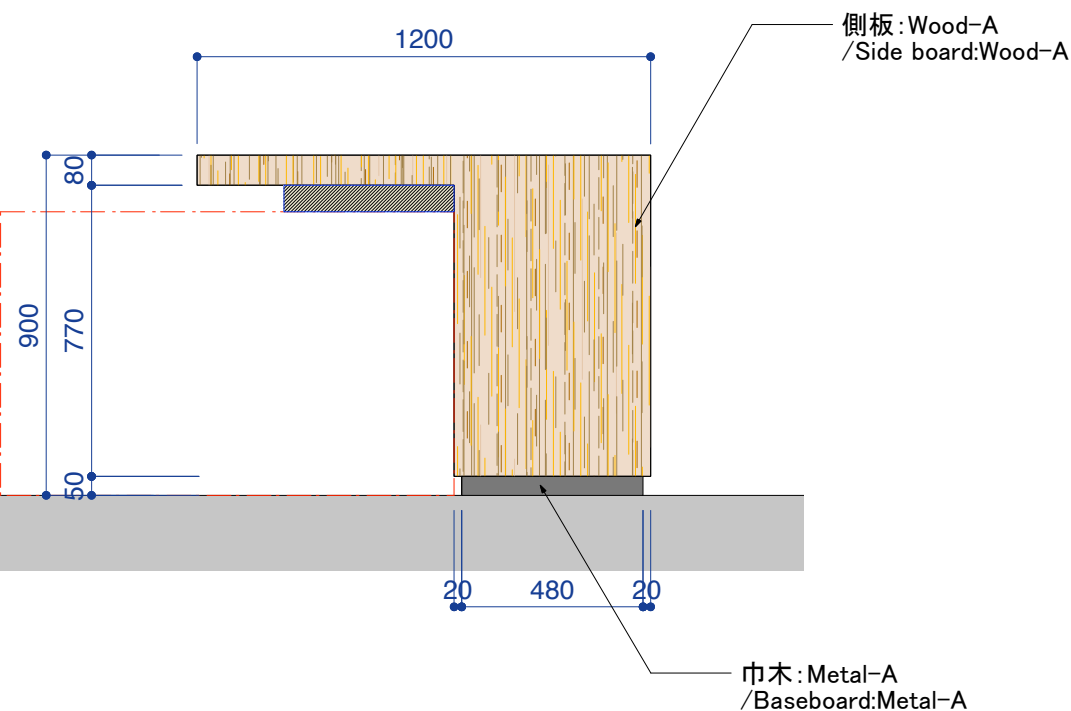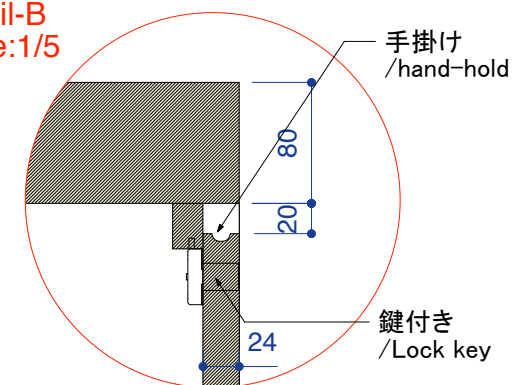

JAPAN TRADITIONAL CRAFTS
DENSAN

TITLE

DISPLAY TABLE-A

STAND No. 8.0 M55

55sqm/CH3500mm

REVISIONS

2018/11/09

EVENT No.

190020000

COSTOMER No.

15022046

DESIGN BY:

TRUNK LTD.

DRAWN BY:

I.Ishikawa

SCALE:

1:20,1:10

SHEET No.

 
07


TRUNK LTD.
design consulting & produce

Seizan I #1002
2-26-32 Minamiaoyama Minato-ku
TOKYO JAPAN #107-0062


T: +81-3-6804-1261
F: +81-3-3403-2360

【仕上げ/finish schedule】


Wood-A/facia : メラミン化粧板/Melamine decorative plate TJY 2070K/AICA	
Wood-B/inside finish : ポリエステル化粧ボード/Polyester-resin treaed plywood LP-2070/AICA	
Metal-A/baceboard メラミン化粧板/Melamine decorative plate ME-2932/AICA	

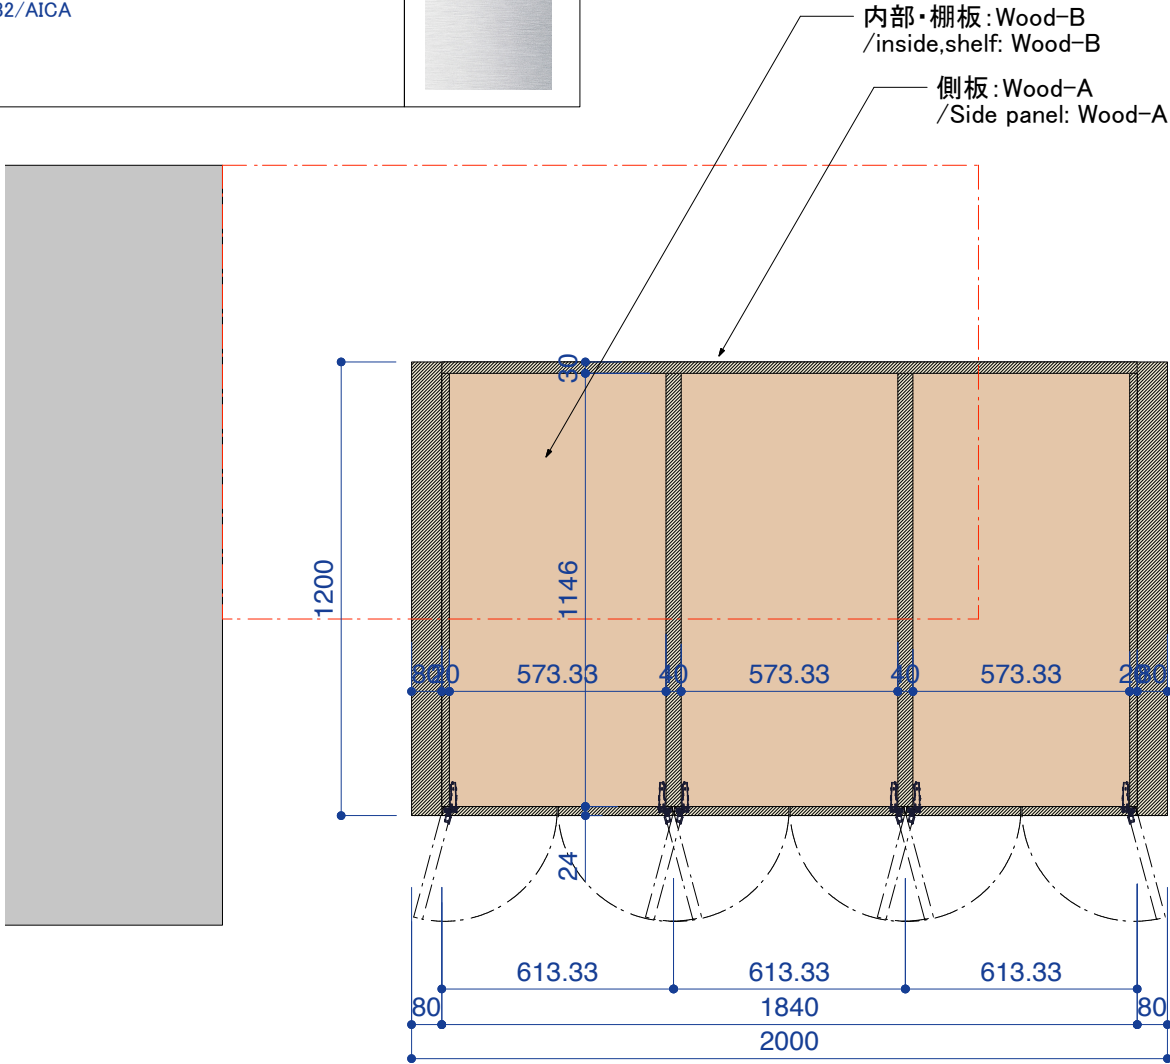



section A
scale:1/10

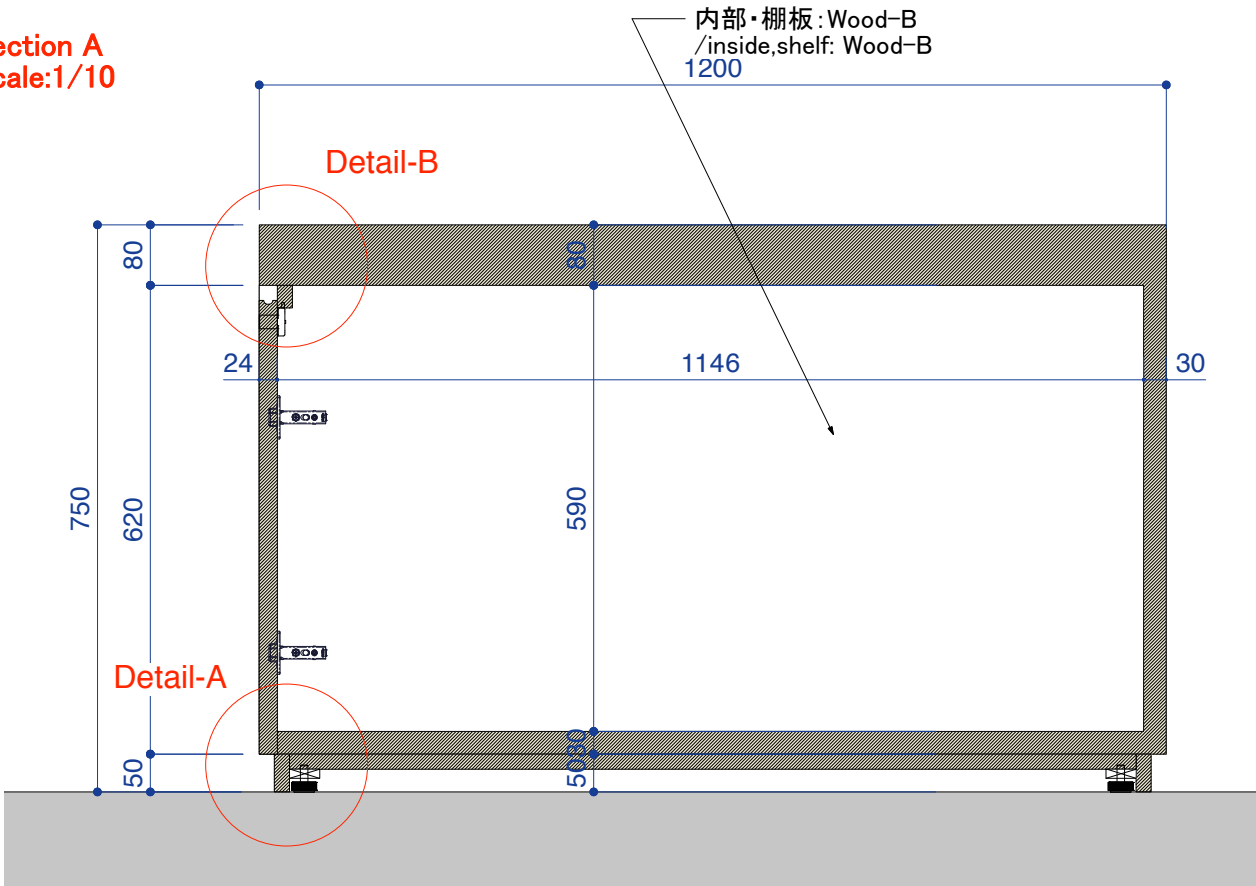



Detail-A
scale:1/5

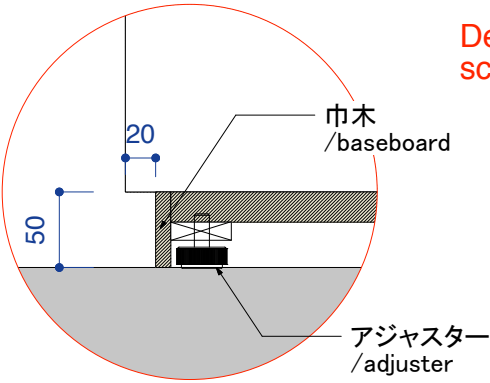

Detail-B
scale:1/5

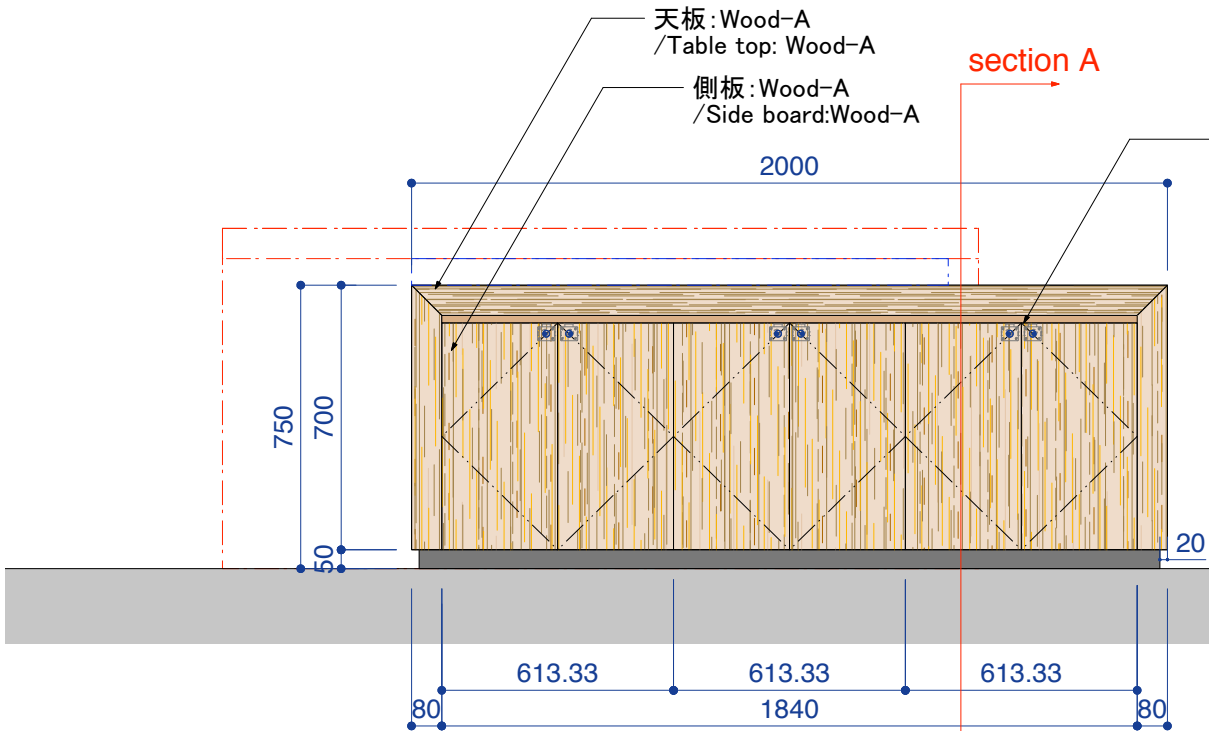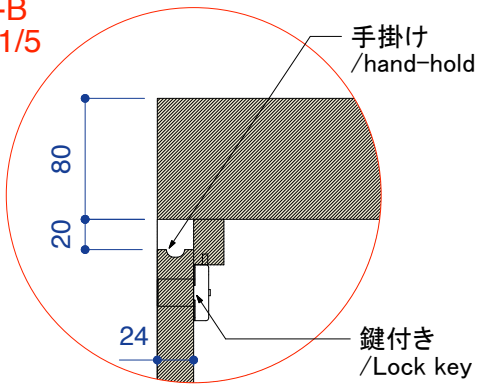

section A






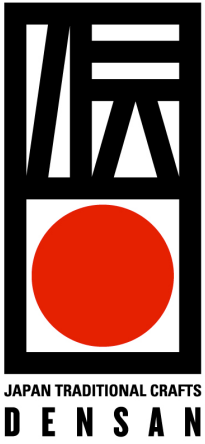
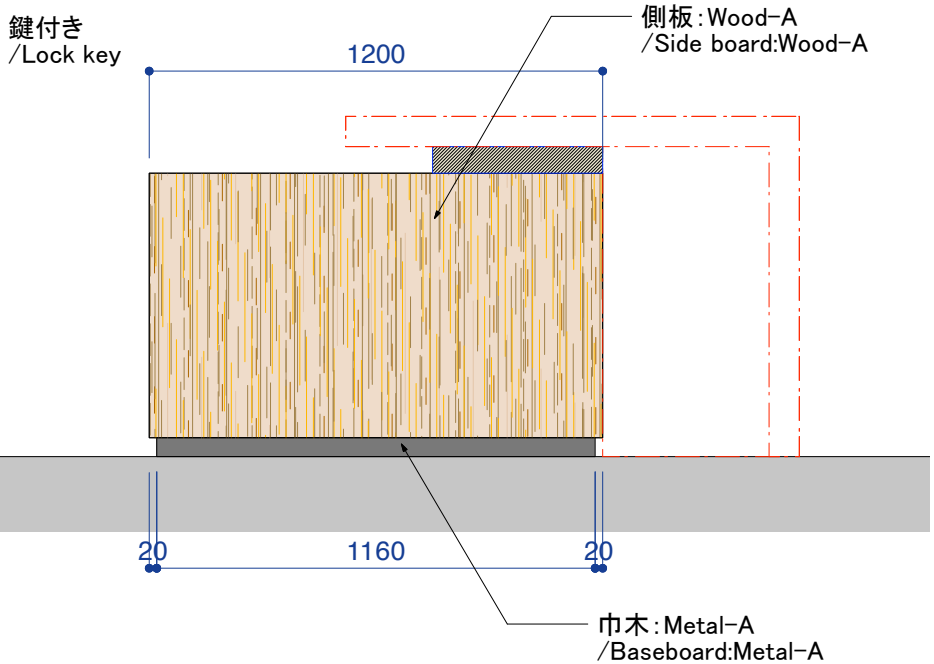


TITLE
DISPLAY TABLE-B
STAND No. 8.0 M55
55sqm/CH3500mm
REVISIONS
2018/11/09
EVENT No.
190020000
COSTOMER No.
15022046
DESIGN BY:
TRUNK LTD.
DRAWN BY:
I.Ishikawa
SCALE:
1:20,1:10
SHEET No.
08


TRUNK LTD.
design consulting & produce
Seizan I #1002
2-26-32 Minamiaoyama Minato-ku
TOKYO JAPAN #107-0062
T: +81-3-6804-1261
F: +81-3-3403-2360

【仕上げ/finish schedule】

Wood-A/facia : メラミン化粧板/Melamine decorative plate TJY 2070K/AICA	
Wood-B/inside finish : ポリエステル化粧板/Polyester-resin treaed plywood LP-2070/AICA	
Metal-A/baceboard メラミン化粧板/Melamine decorative plate ME-2932/AICA	

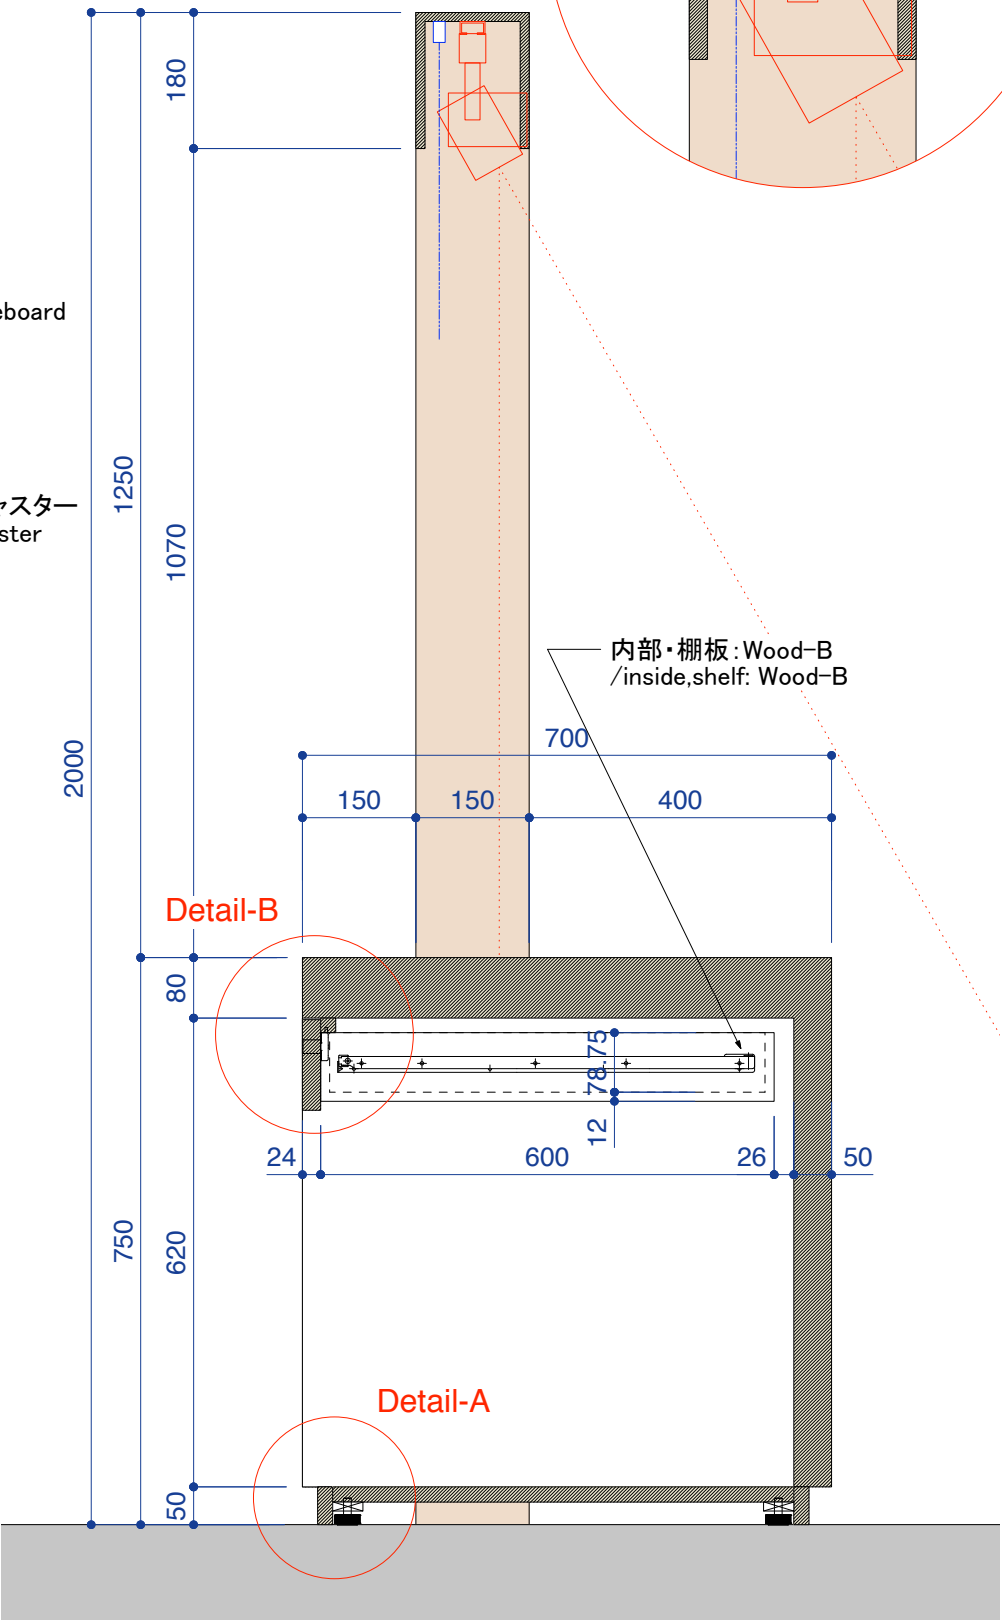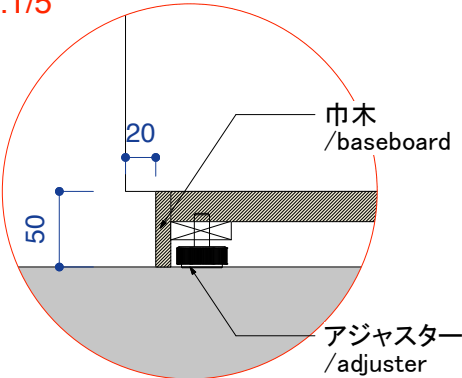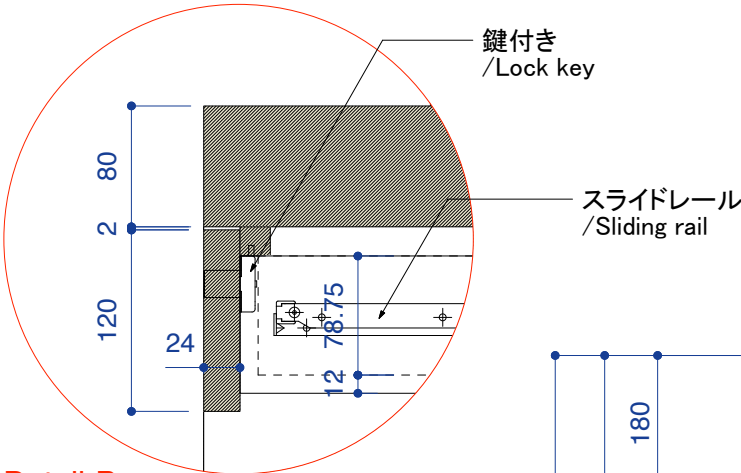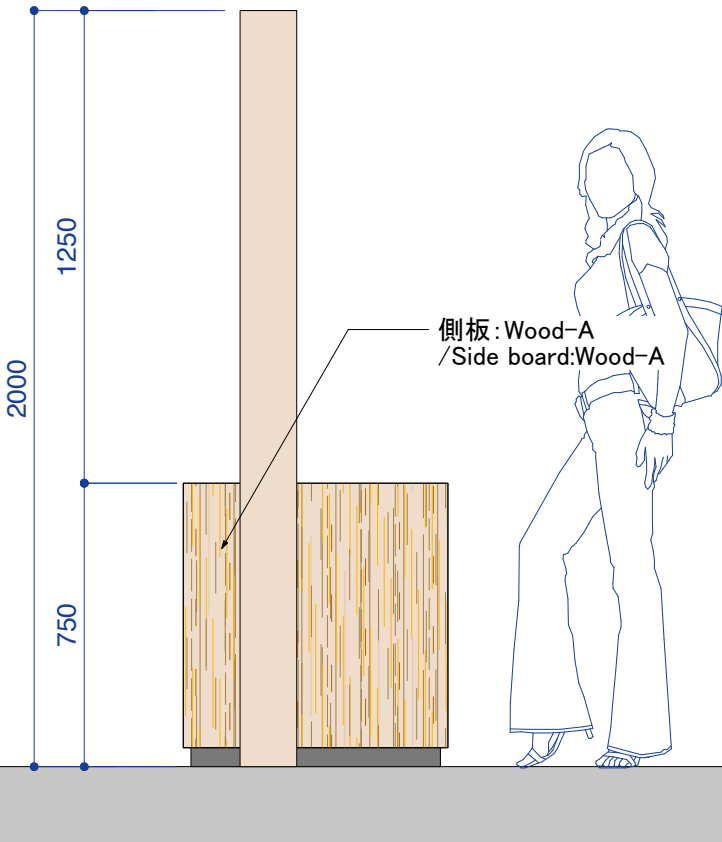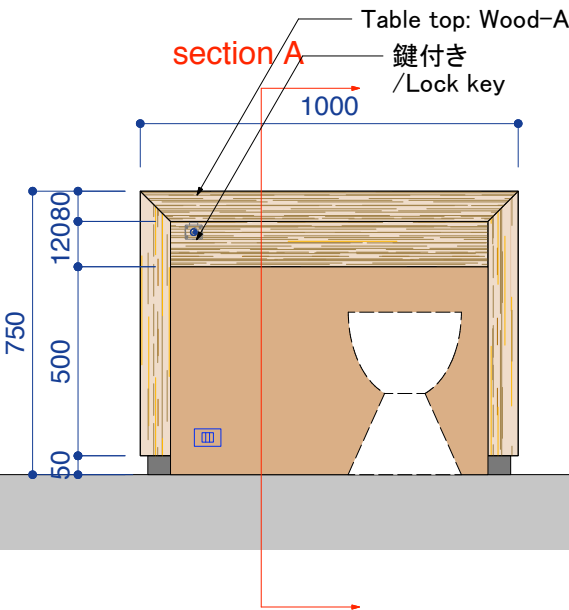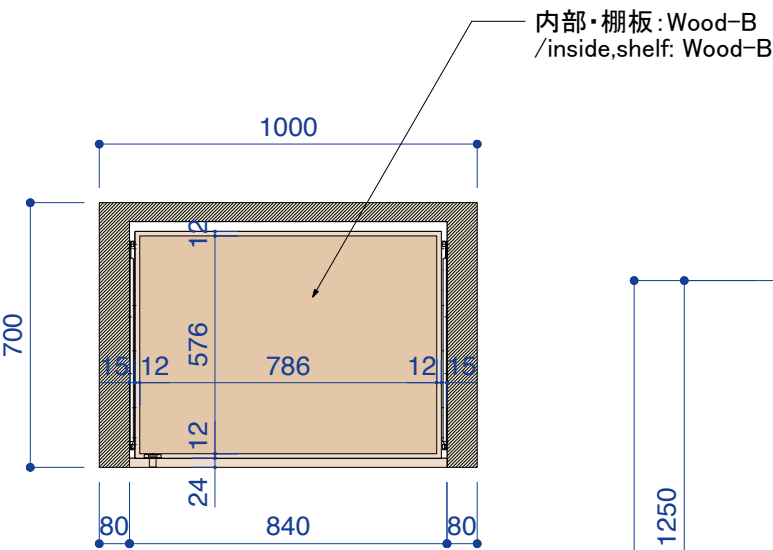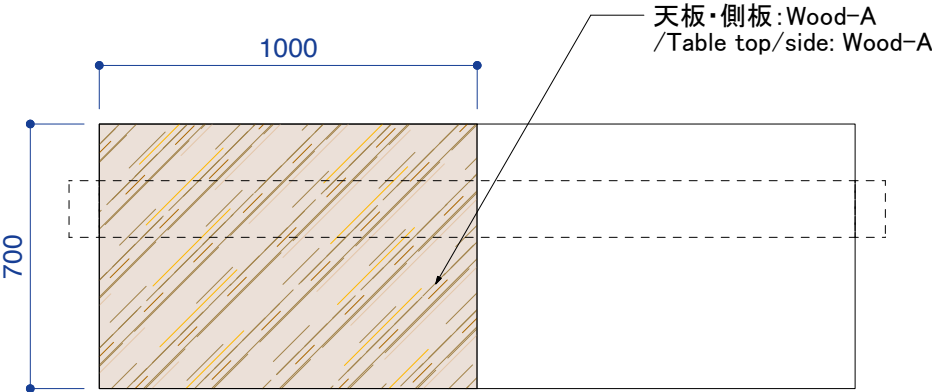

section A
scale:1/10

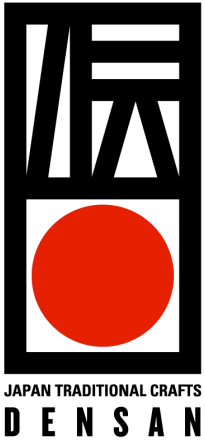


TITLE
BOOTH TABLE
STAND No. 8.0 M55
55sqm/CH3500mm
REVISIONS
2018/11/09
EVENT No.
190020000
COSTOMER No.
15022046
DESIGN BY:
TRUNK LTD.
DRAWN BY:
I.Ishikawa
SCALE:
1:20,1:10
SHEET No.
09


TRUNK LTD.
design consulting & produce
Seizan I #1002
2-26-32 Minamiaoyama Minato-ku
TOKYO JAPAN #107-0062
T: +81-3-6804-1261
F: +81-3-3403-2360

【仕上げ/finish schedule】


Wood-A/facia : メラミン化粧板/Melamine decorative plate TJY 2070K/AICA	
Wood-B/inside finish : ポリ版化粧ボード/Polyester-resin treaed plywood LP-2070/AICA	
Metal-A/baceboard メラミン化粧板/Melamine decorative plate ME-2932/AICA	

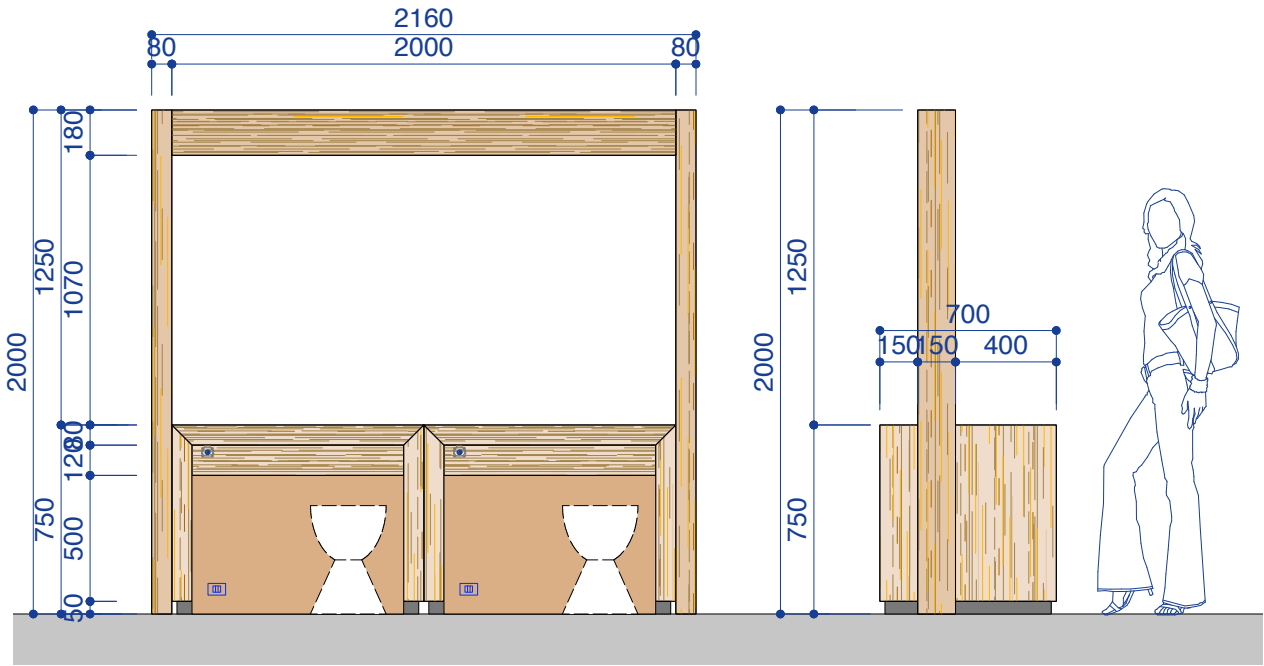


Booth unit A x1

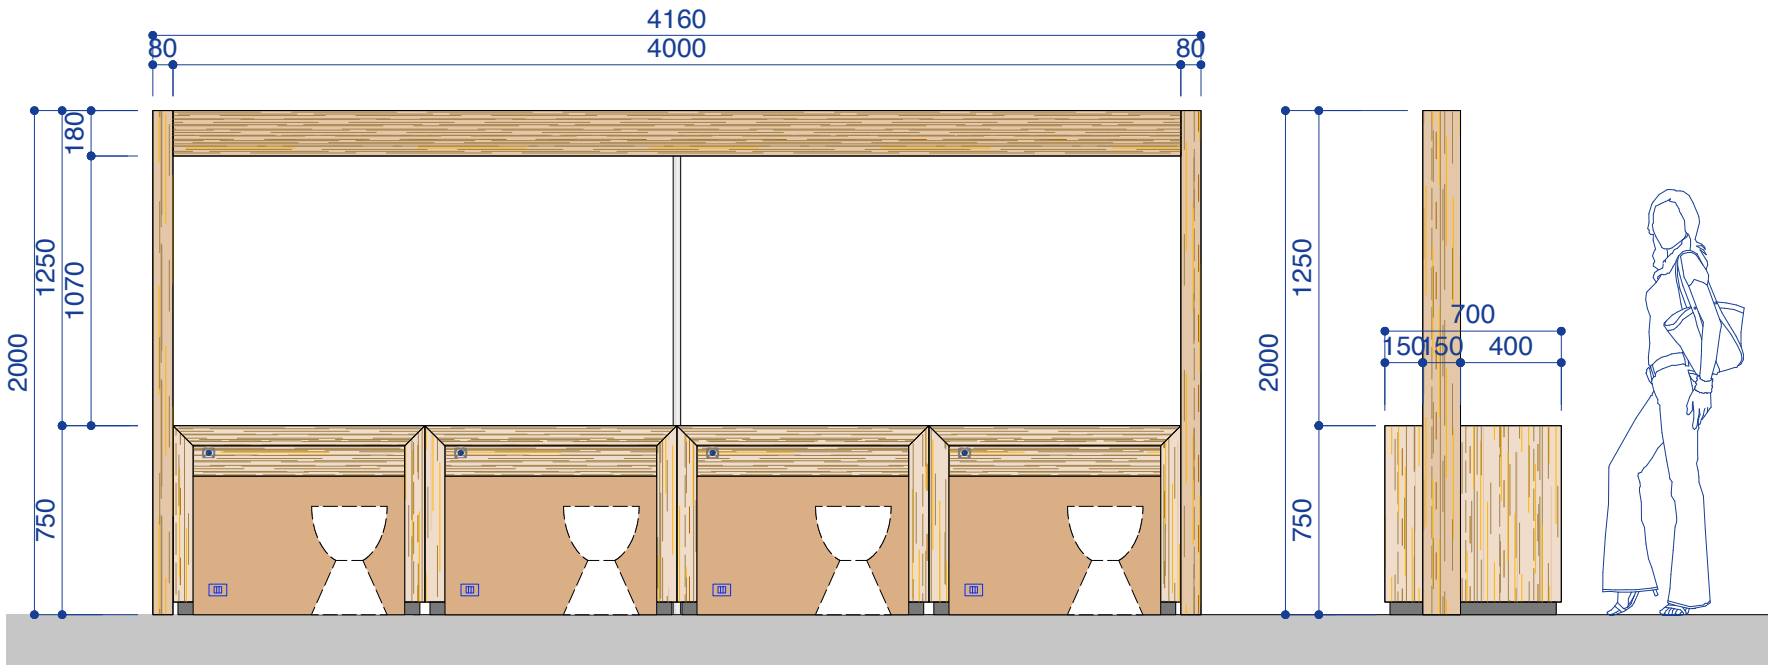

Booth unit B x1

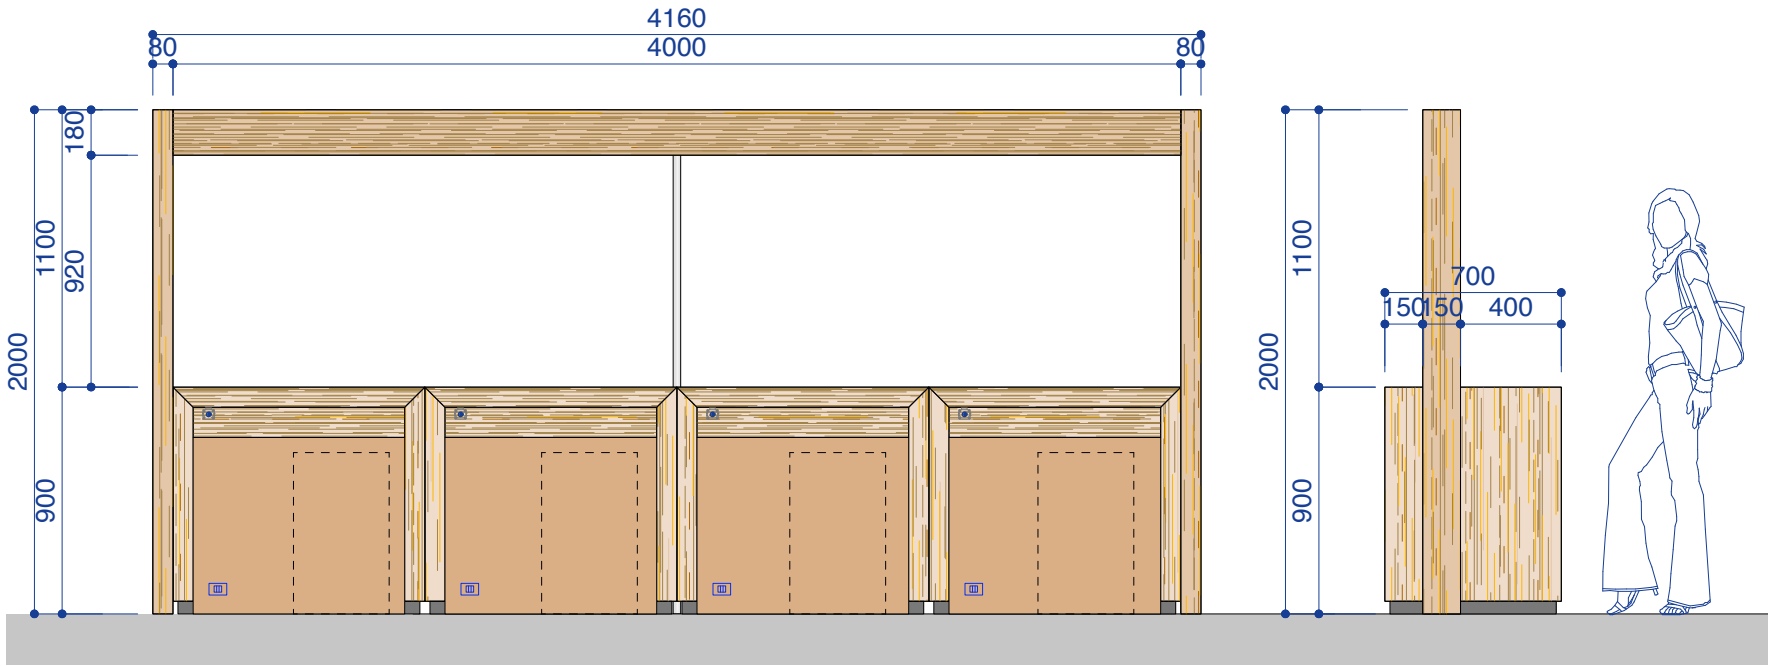

Booth unit C x1

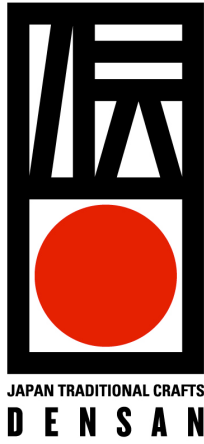

TITLE

BOOTH TABLE UNIT

STAND No. 8.0 M55

55sqm/CH3500mm

REVISIONS

2018/11/09

EVENT No.

190020000

COSTOMER No.

15022046

DESIGN BY:

TRUNK LTD.

DRAWN BY:

I.Ishikawa

SCALE:

1:30

SHEET No.

10

TRUNK LTD.
design consulting & produce

Seizan I #1002
2-26-32 Minamiaoyama Minato-ku
TOKYO JAPAN #107-0062

T: +81-3-6804-1261
F: +81-3-3403-2360